


NOT FOR CONSTRUCTION

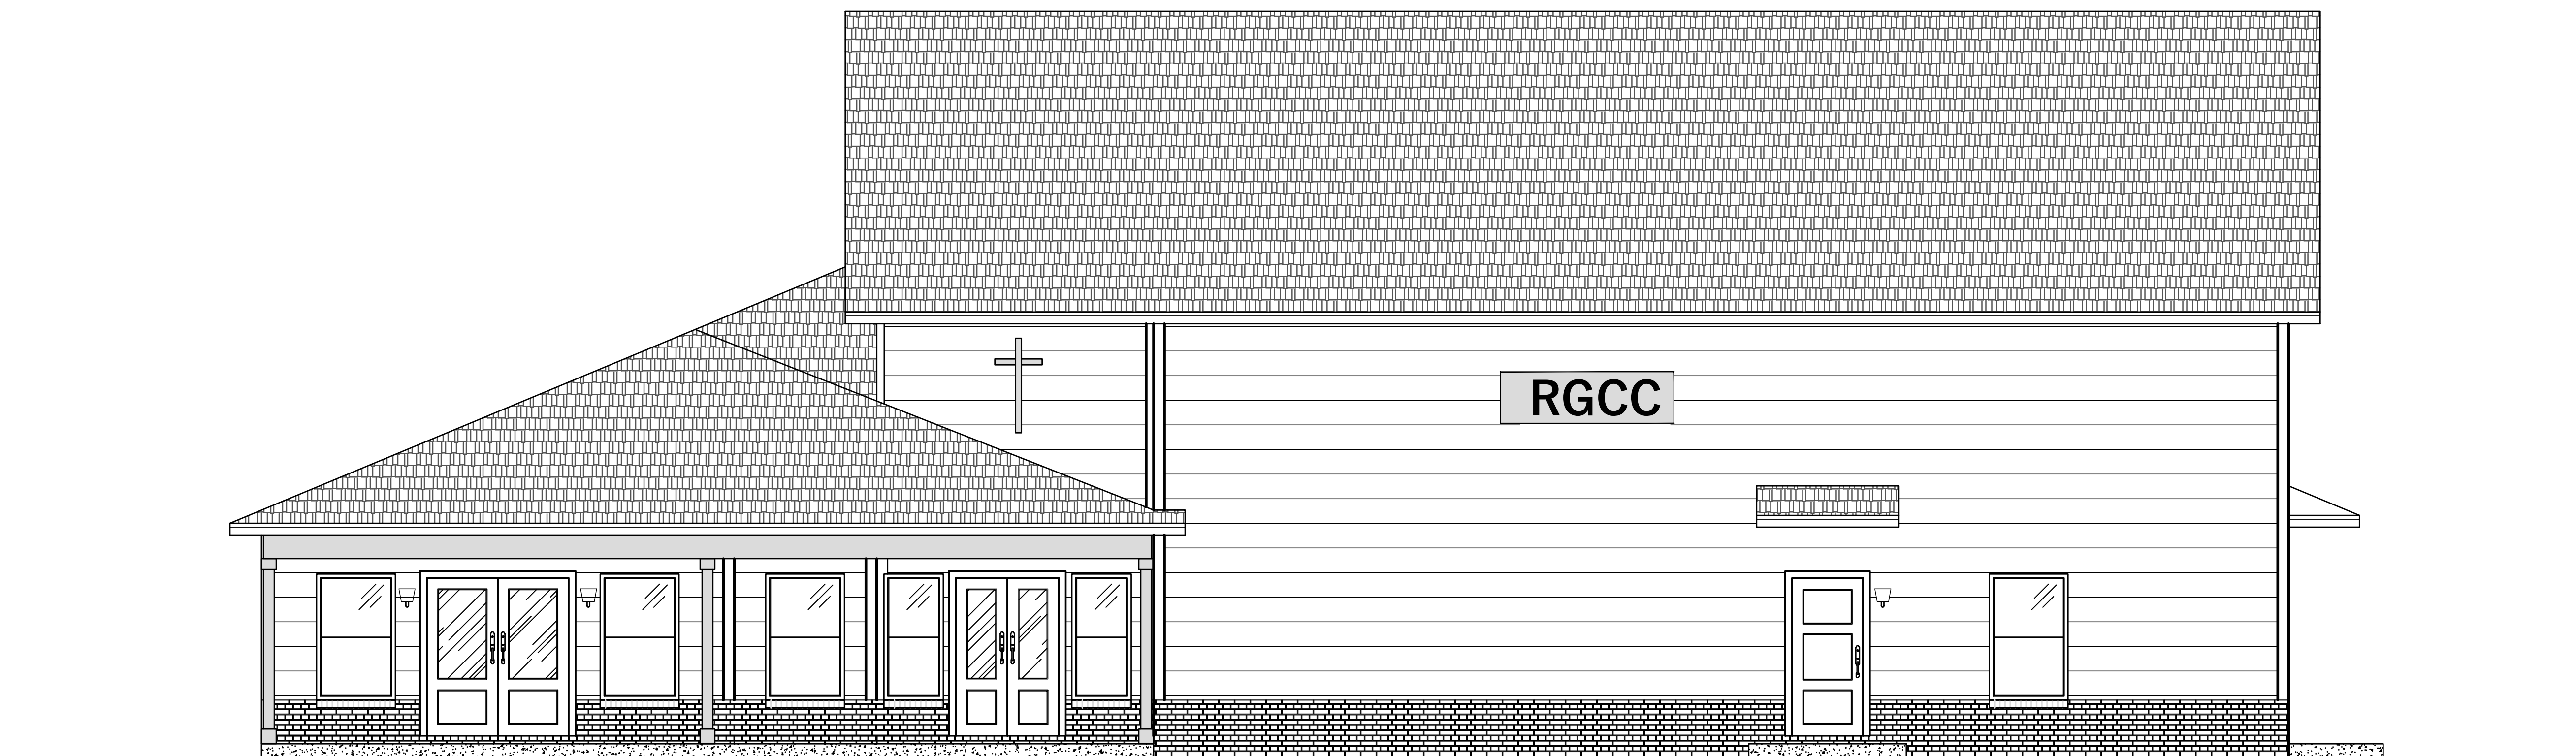

- CS1.0-COVER SHEET
- ASP1.0 SITE PLAN
- A1.1 - FLOOR PLAN
- AE1.2 - ELECTRICAL PLAN
- A1.3 - FOUNDATION PLAN
- A1.4 - ROOF PLAN
- A1.5 - DETAIL PLAN
- A1.6 - ELEVATION PLAN
- A1.7 - ELEVATION PLAN

General Notes

CONTRACTOR: TO VERIFY ALL DIMENSION ON SITE OF PROJECT

No.	Revision/Issue	Date

Firm Name and Address
 SLOAN'S DRAFTING
 96 ALLEN RANCH LANE
 HAVANA, FL 32333
 (850)-339-1778
 sloansdrafting@gmail.com

Project Name and Address
 RESTORED GLORY CHRISTIAN CENTER
 1346 S JEFFERSON ST.
 MONTICELLO, FL 32344

Project CHURCH DESIGN	Sheet
Date 10/31/23	CS1.0
Scale 1/4"=1'-0"	


NOTE:
CONTRACTOR TO PROVIDE SILT
SCREEN AND WATER DRAINAGE
DURING CONSTRUCTION

NOTE:
"VERIFY FOR PROTECTED
TREE ON SITE"

NOTE:
"THIS IS NOT A SURVEY"



General Notes
CONTRACTOR: TO VERIFY ALL
DIMENSION ON SITE OF PROJECT

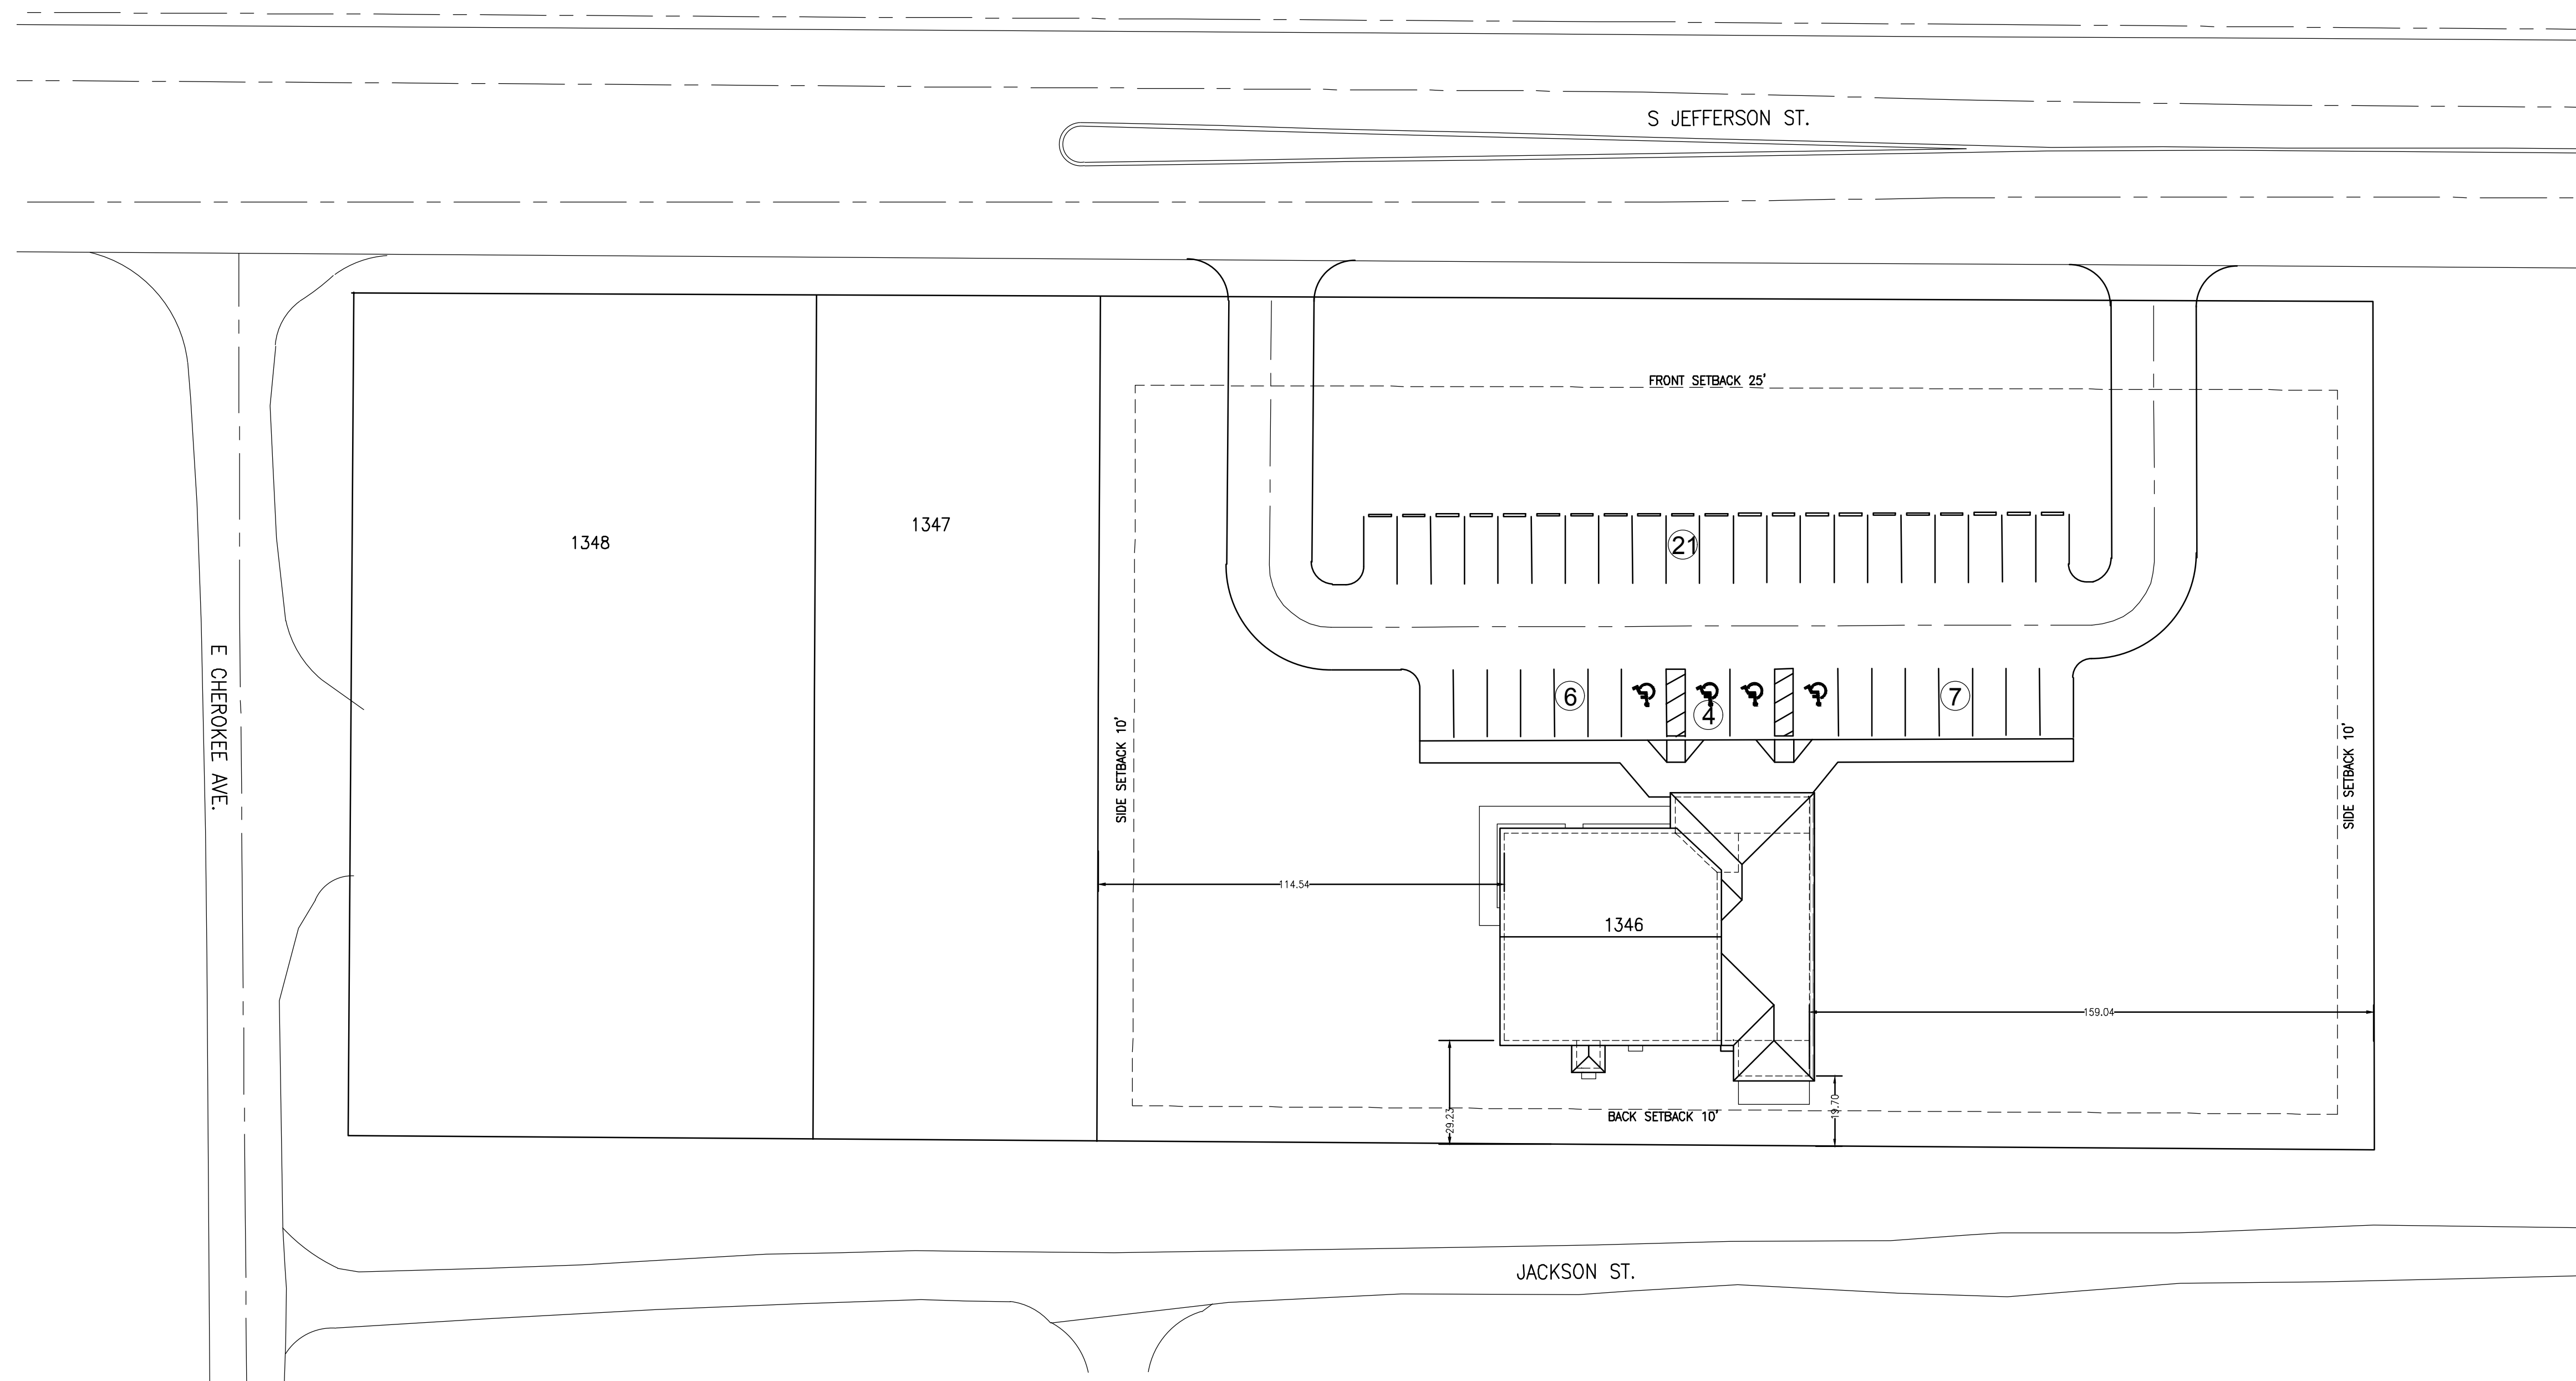

SITE PLAN

SCALE: 1"=30'-0"


No.	Revision/Issue	Date

Firm Name and Address
SLOAN'S DRAFTING
96 ALLEN RANCH LANE
HAVANA, FL 32333
(850)-339-1778
sloansdrafting@gmail.com

Project Name and Address
RESTORED GLORY CHRISTIAN CENTER
1346 S JEFFERSON ST.
MONTICELLO, FL 32344


Project CHURCH DESIGN	Sheet ASP1.0
Date 10/31/23	
Scale 1"=30'-0"	

NOT FOR CONSTRUCTION

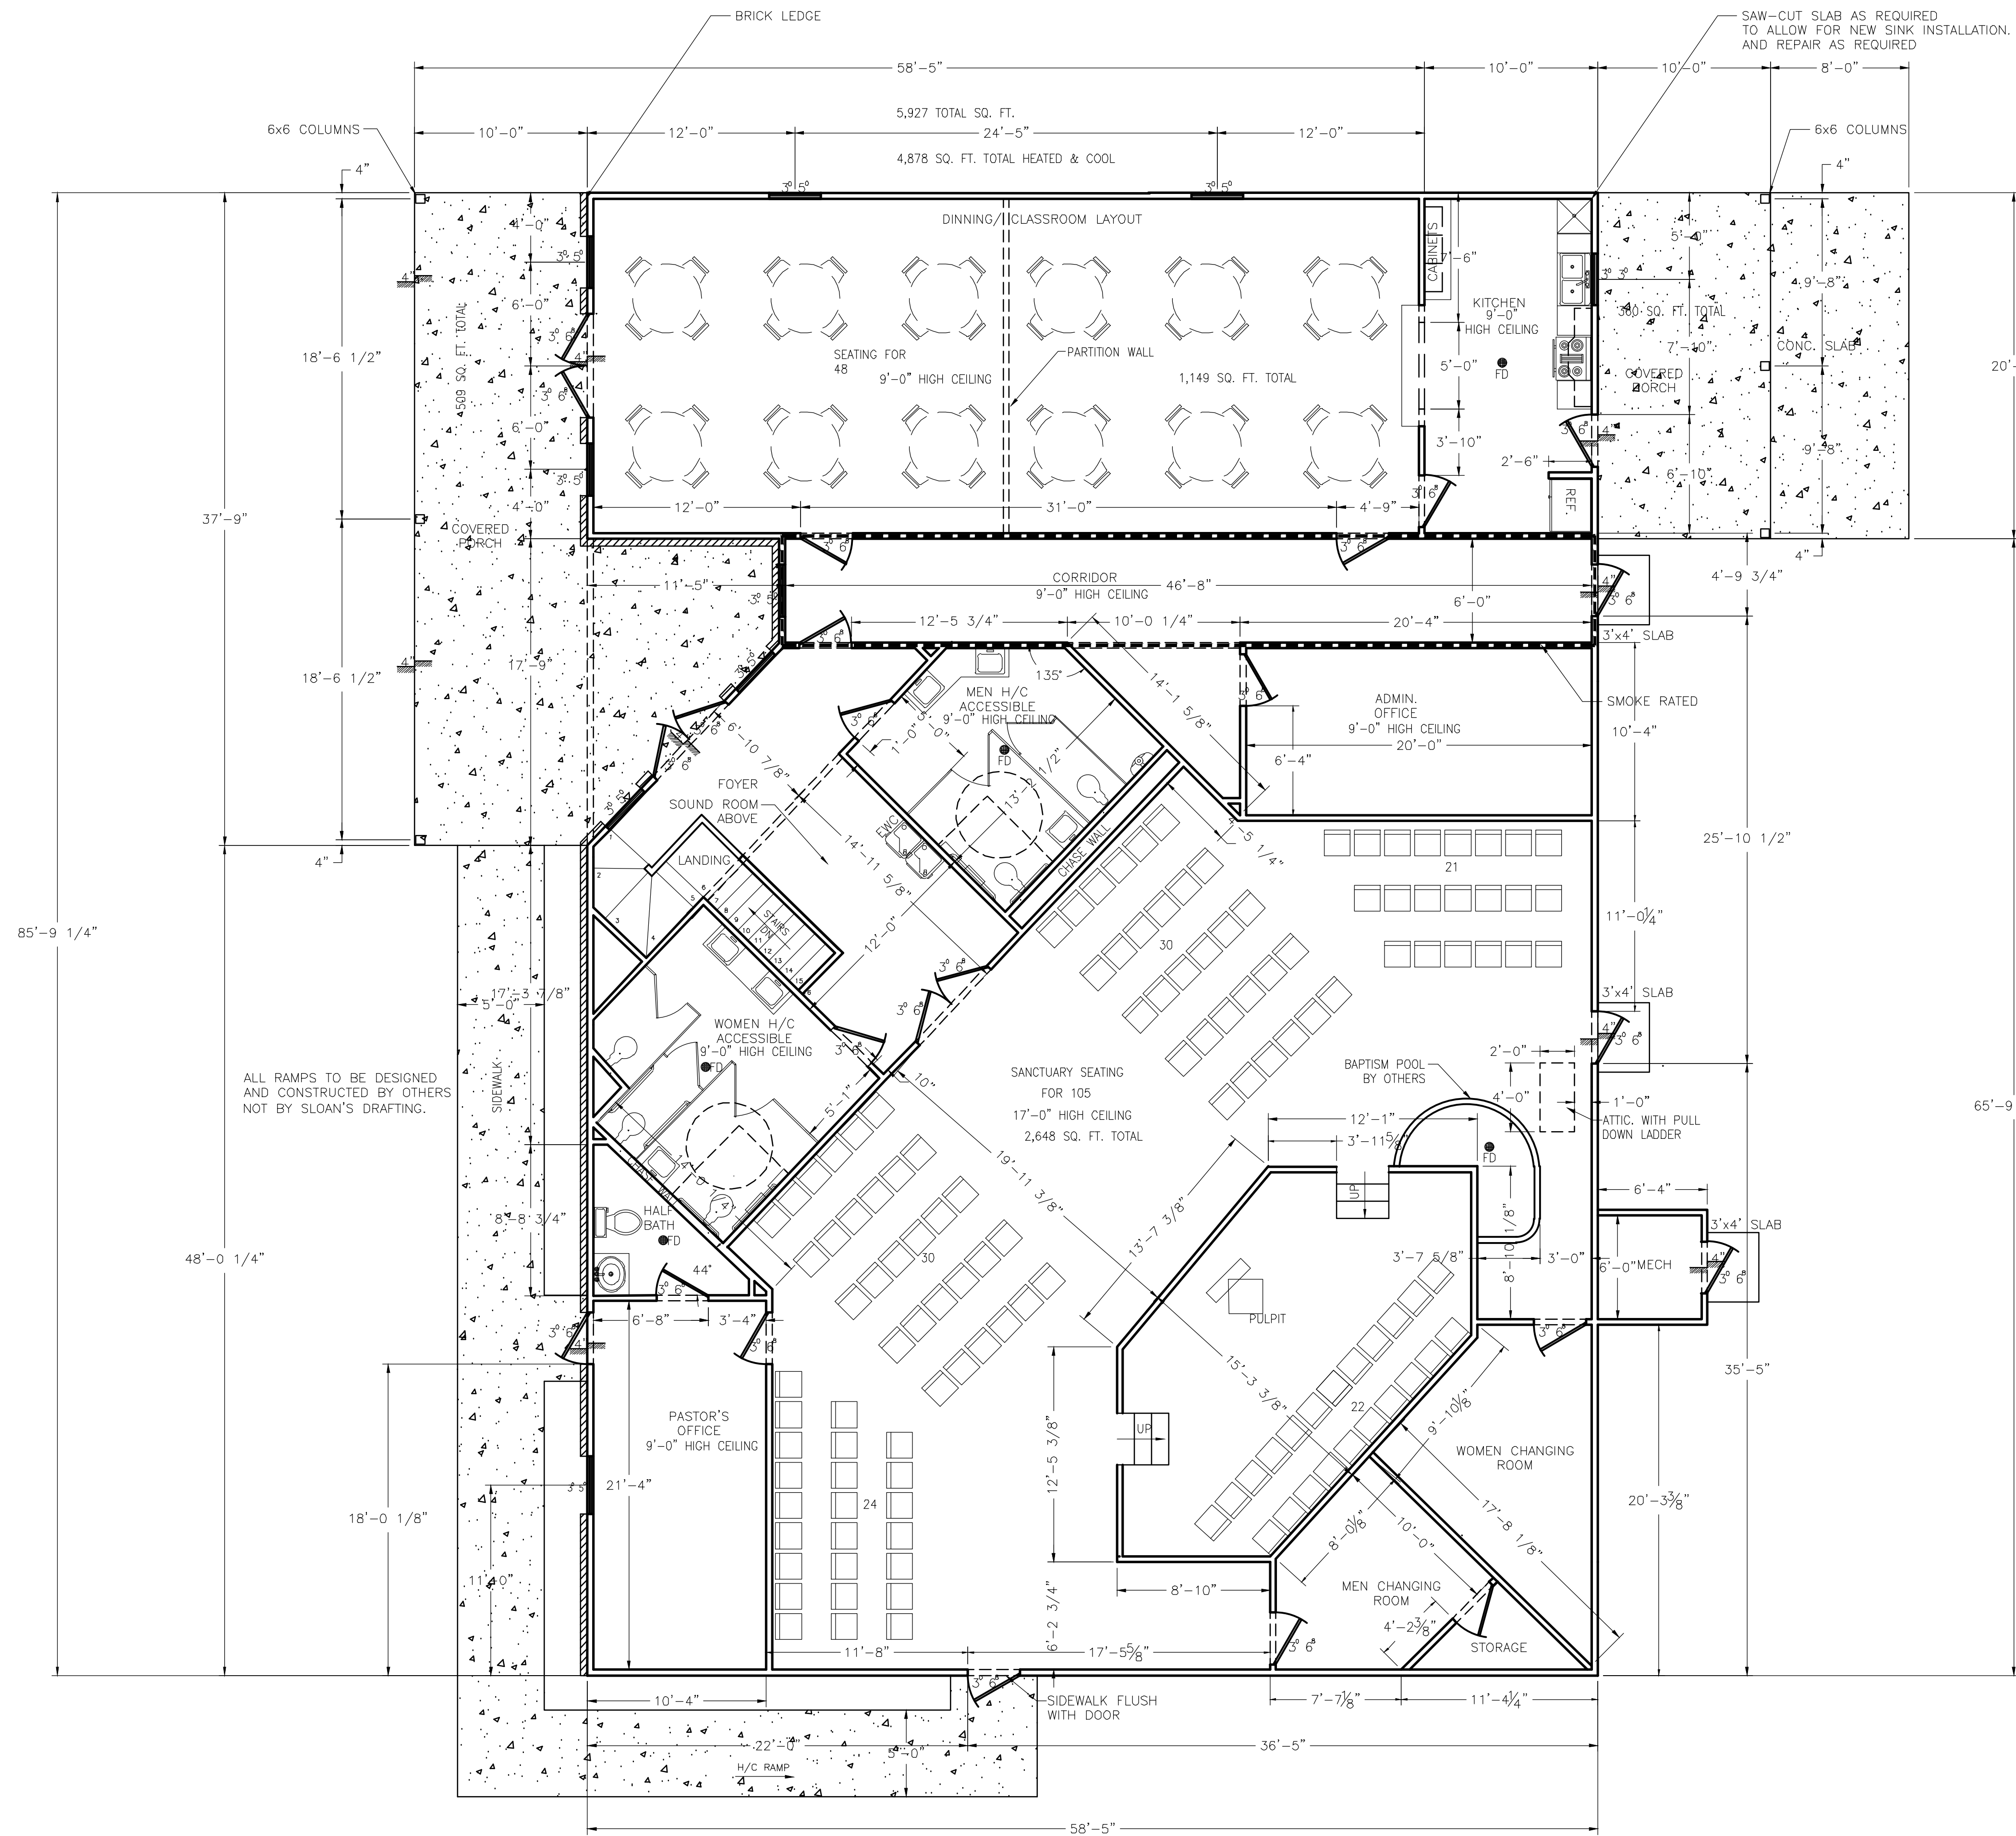

SQUARE FOOTAGE

HEAT & COOL	4,917 sq. ft.
FRONT PORCH	509 sq. ft.
REAR PORCH	360 sq. ft.
SOUND ROOM	180 sq. ft.
TOTAL	5,966 sq. ft.

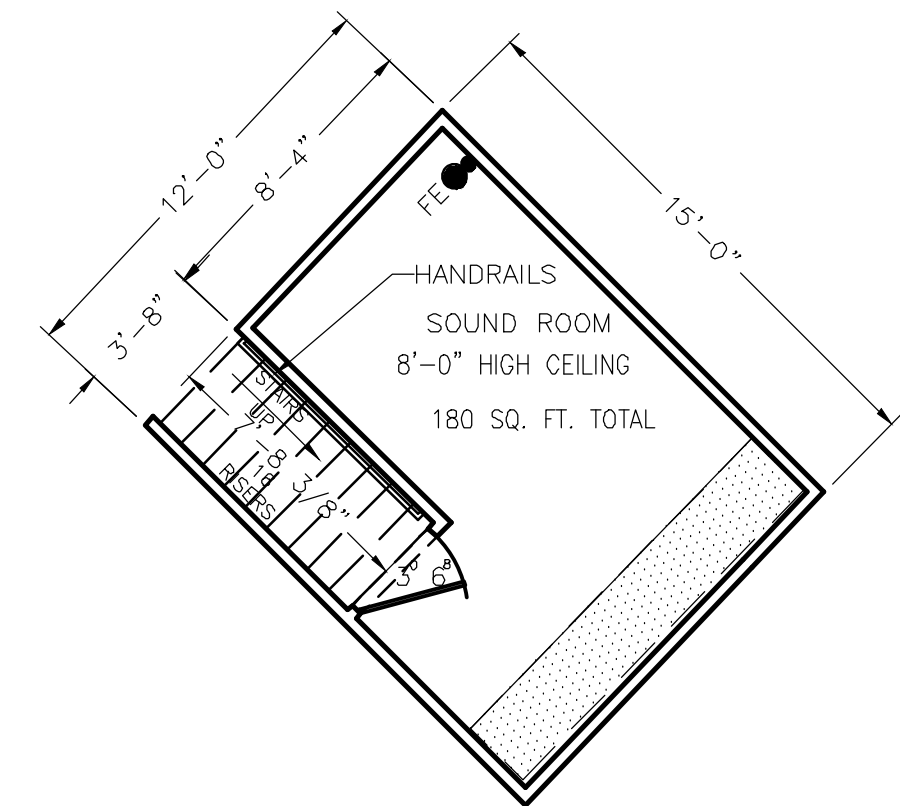

SOUND ROOM SCALE: 3/16"=1'-0"

FLOOR PLAN SCALE: 3/16"=1'-0"

General Notes
 CONTRACTOR: TO VERIFY ALL DIMENSION ON SITE OF PROJECT


No.	Revision/Issue	Date

Firm Name and Address
 SLOAN'S DRAFTING
 96 ALLEN RANCH LANE
 HAVANA, FL 32333
 (850)-339-1778
 sloansdrafting@gmail.com

Project Name and Address
 RESTORED GLORY CHRISTIAN CENTER
 1346 S JEFFERSON ST.
 MONTICELLO, FL 32344

 



 
 
 
 
 
 
 


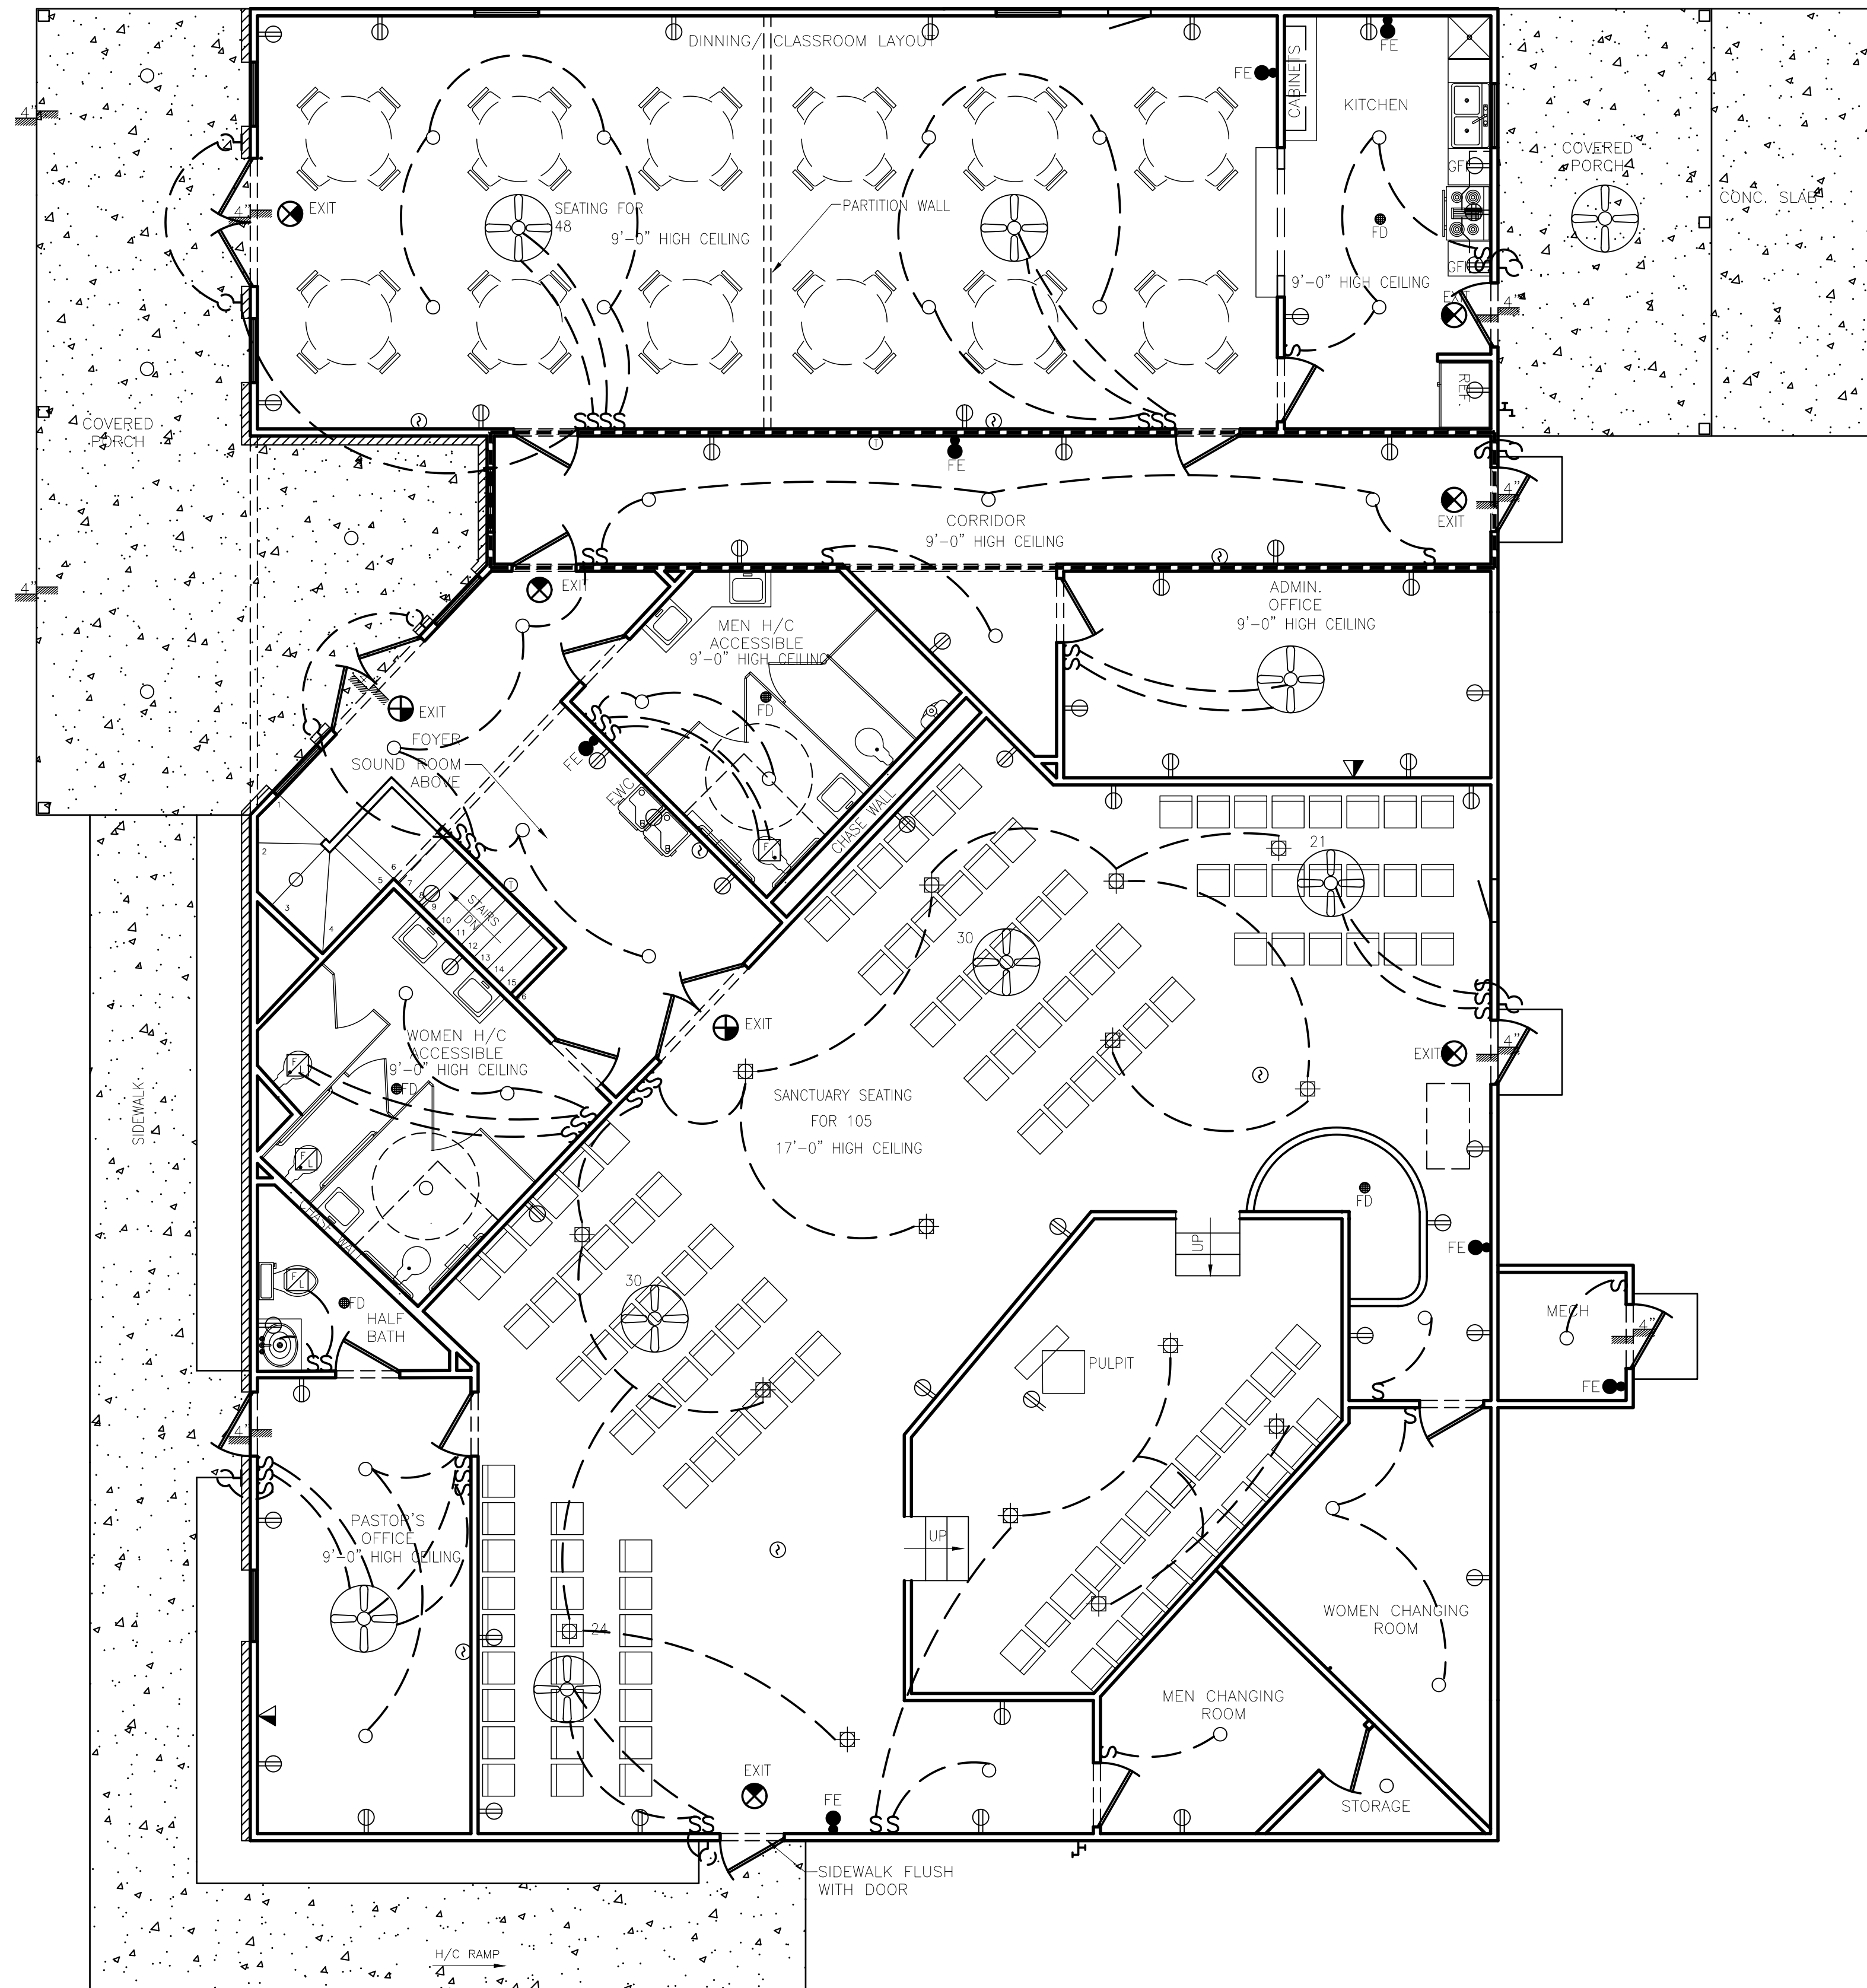


Project	Sheet
CHURCH DESIGN	
Date	
10/31/23	
Scale	
3/16"=1'-0"	A1.1


NOT FOR CONSTRUCTION



ELECTRICAL FLOOR PLAN

SCALE: 3/16"=1'-0"

-  DUPLEX RECEPTACLE, 20A, 125V, 2 POLE, 3 WIRE, MOUNT 1'-6" AFF, NEMA 5-20R.
-  FLUSH TYPE, 20A, 120/277V AC ONLY, QUIET TYPE, SINGLE POLE SWITCH
-  TELEPHONE / DATA OUTLET, MOUNT 1'-6" AFF
-  LIGHTING FIXTURE AND CEILING FAN
-  WALL MOUNTED LIGHTING FIXTURE
-  FIRE ALARM PHOTOELECTRIC SMOKE DETECTOR - CEILING MOUNTED
-  DUPLEX RECEPTACLE, 20A, 125V, 2 POLE, 3 WIRE, WITH WEATHERPROOF-IN-USE COVER
-  HOSE BIB
-  EXHAUST FAN AND LIGHT
-  LIGHTING FIXTURE
-  THERMOSTAT
-  220 VOLT OUTLET
-  DOUBLE FLOOD LTG.
-  EXHAUST FAN/LIGHT
-  RECESSED CAN LTG.
-  ELECTRICAL PANEL

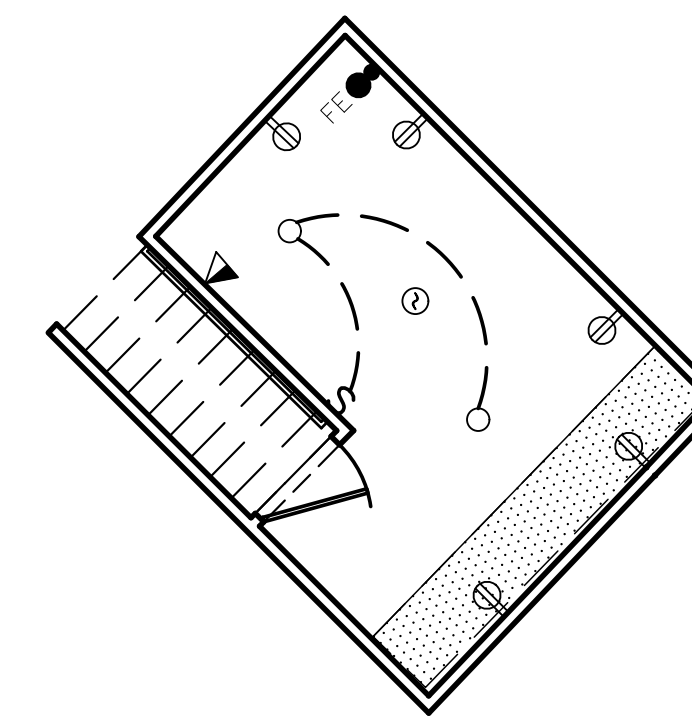

ELECTRICAL SOUND ROOM

SCALE: 3/16"=1'-0"

General Notes

CONTRACTOR: TO VERIFY ALL DIMENSION ON SITE OF PROJECT


No.	Revision/Issue	Date

Firm Name and Address
 SLOAN'S DRAFTING
 96 ALLEN RANCH LANE
 HAVANA, FL 32333
 (850)-339-1778
 sloansdrafting@gmail.com

Project Name and Address
 RESTORED GLORY CHRISTIAN CENTER
 1346 S JEFFERSON ST.
 MONTICELLO, FL 32344


Project CHURCH DESIGN	Sheet
Date 10/31/23	AE1.2
Scale 3/16"=1'-0"	

NOT FOR CONSTRUCTION

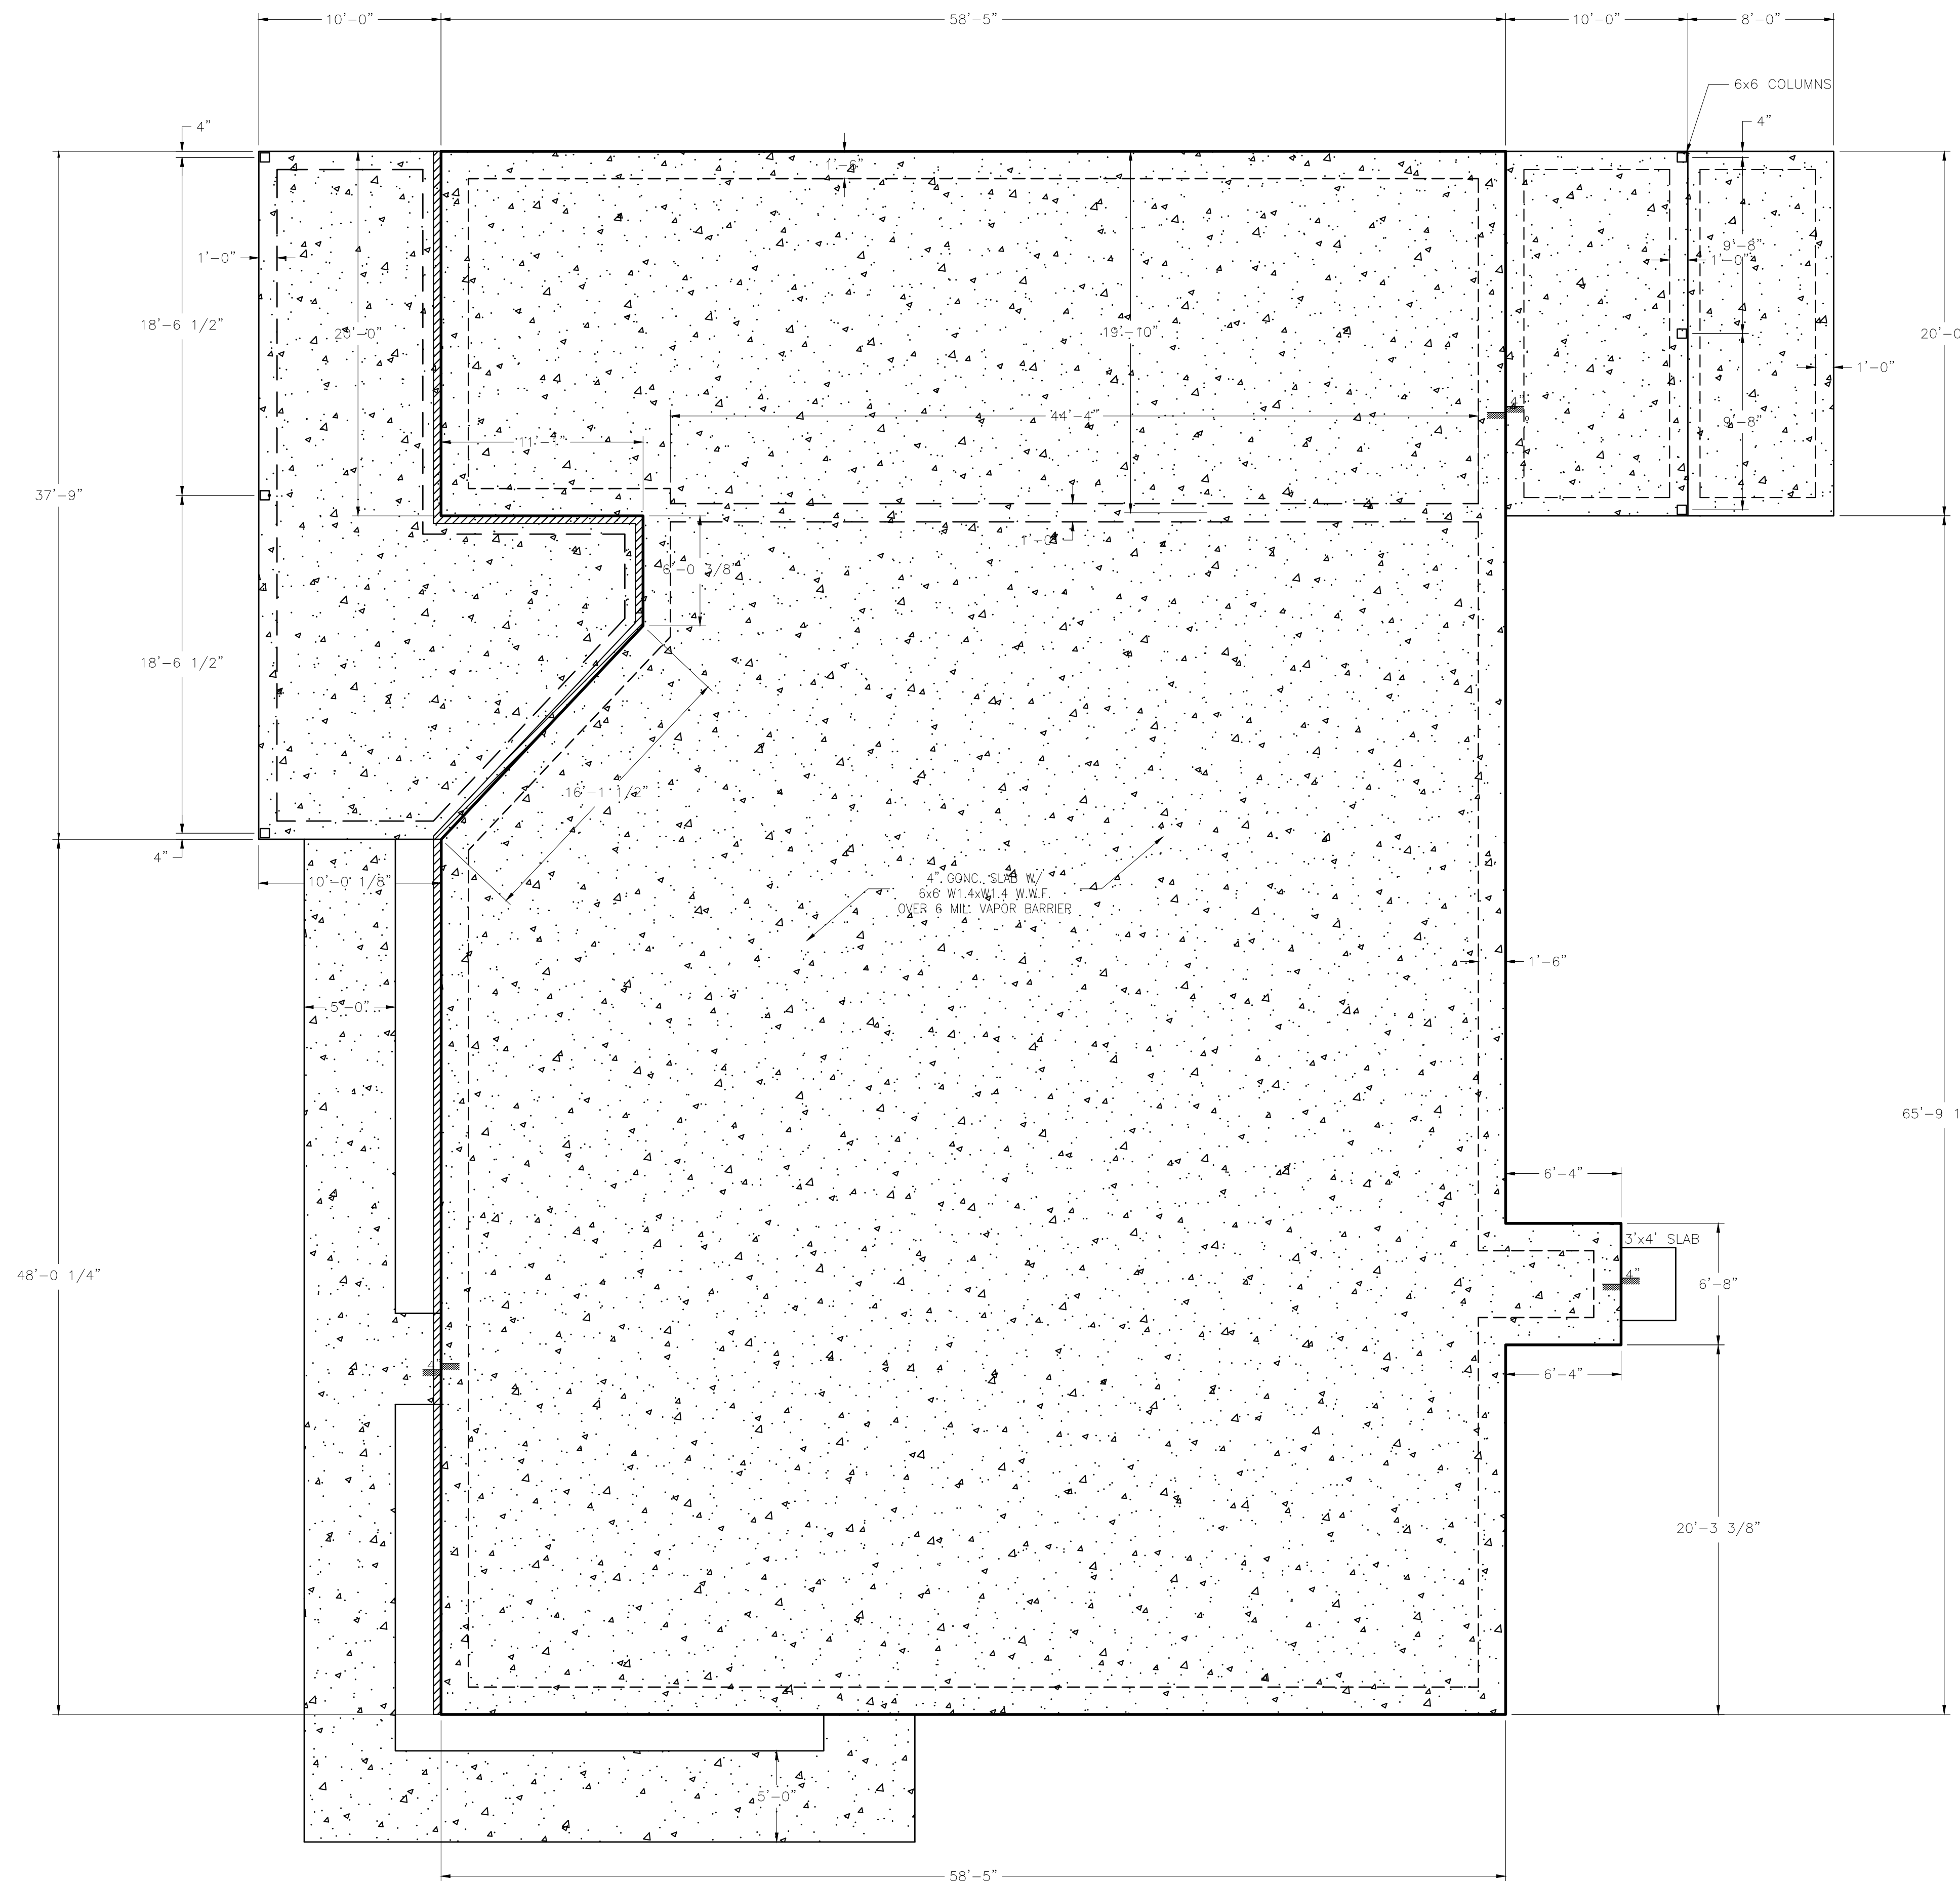

FOUNDATION PLAN

SCALE: 3/16"=1'-0"

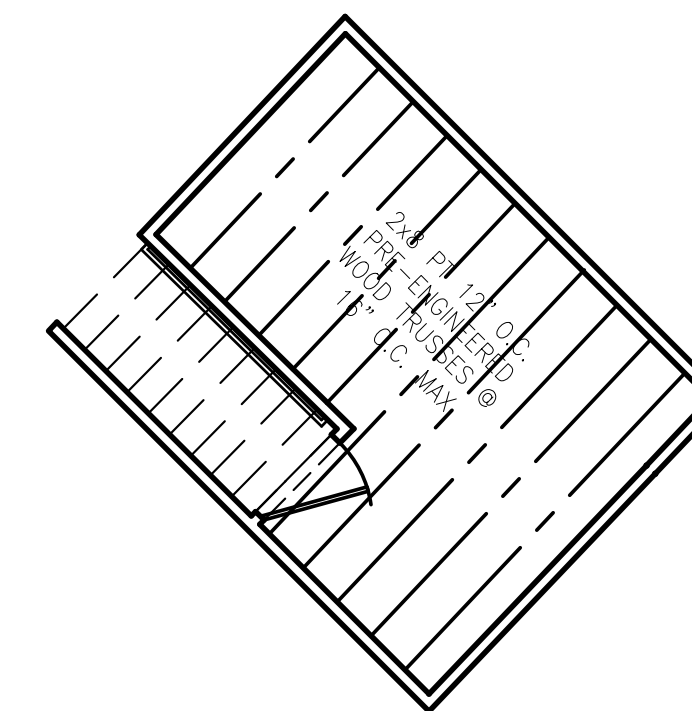

FRAMING PLAN

SCALE: 3/16"=1'-0"

General Notes

CONTRACTOR: TO VERIFY ALL DIMENSION ON SITE OF PROJECT


No.	Revision/Issue	Date

Firm Name and Address
 SLOAN'S DRAFTING
 96 ALLEN RANCH LANE
 HAVANA, FL 32333
 (850)-339-1778
 sloansdrafting@gmail.com


Project Name and Address
 RESTORED GLORY CHRISTIAN CENTER
 1346 S JEFFERSON ST.
 MONTICELLO, FL 32344

Project CHURCH DESIGN	Sheet
Date 10/31/23	A1.3
Scale 3/16"=1'-0"	


NOT FOR CONSTRUCTION

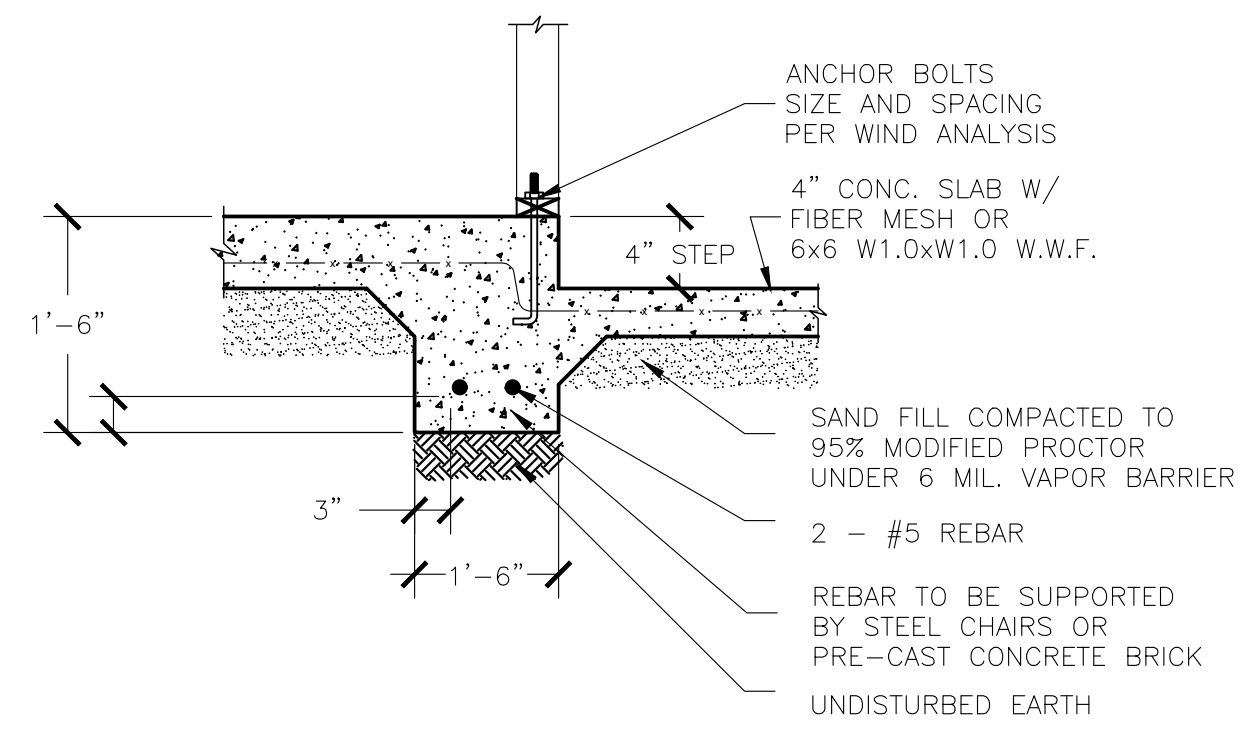


E STEPDOWN DETAIL
SCALE: 3/4"=1'-0"

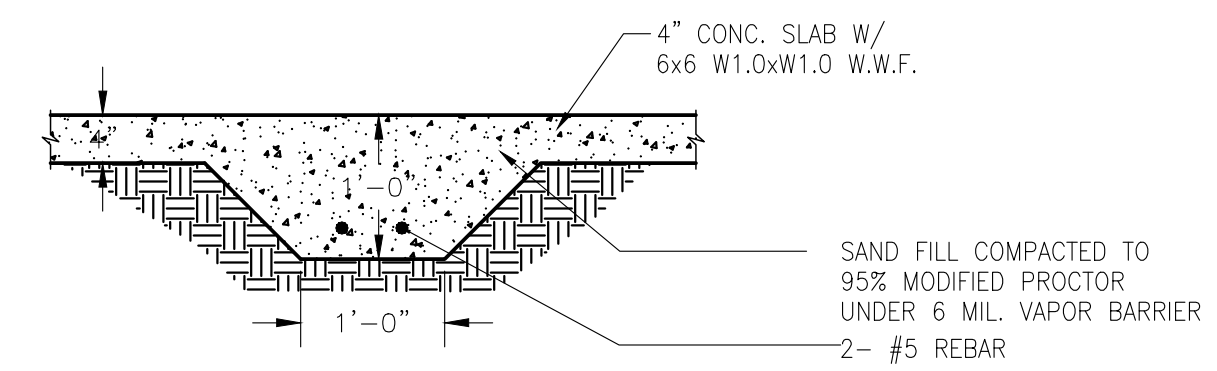


D INTERIOR DETAIL
SCALE: 3/4"=1'-0"

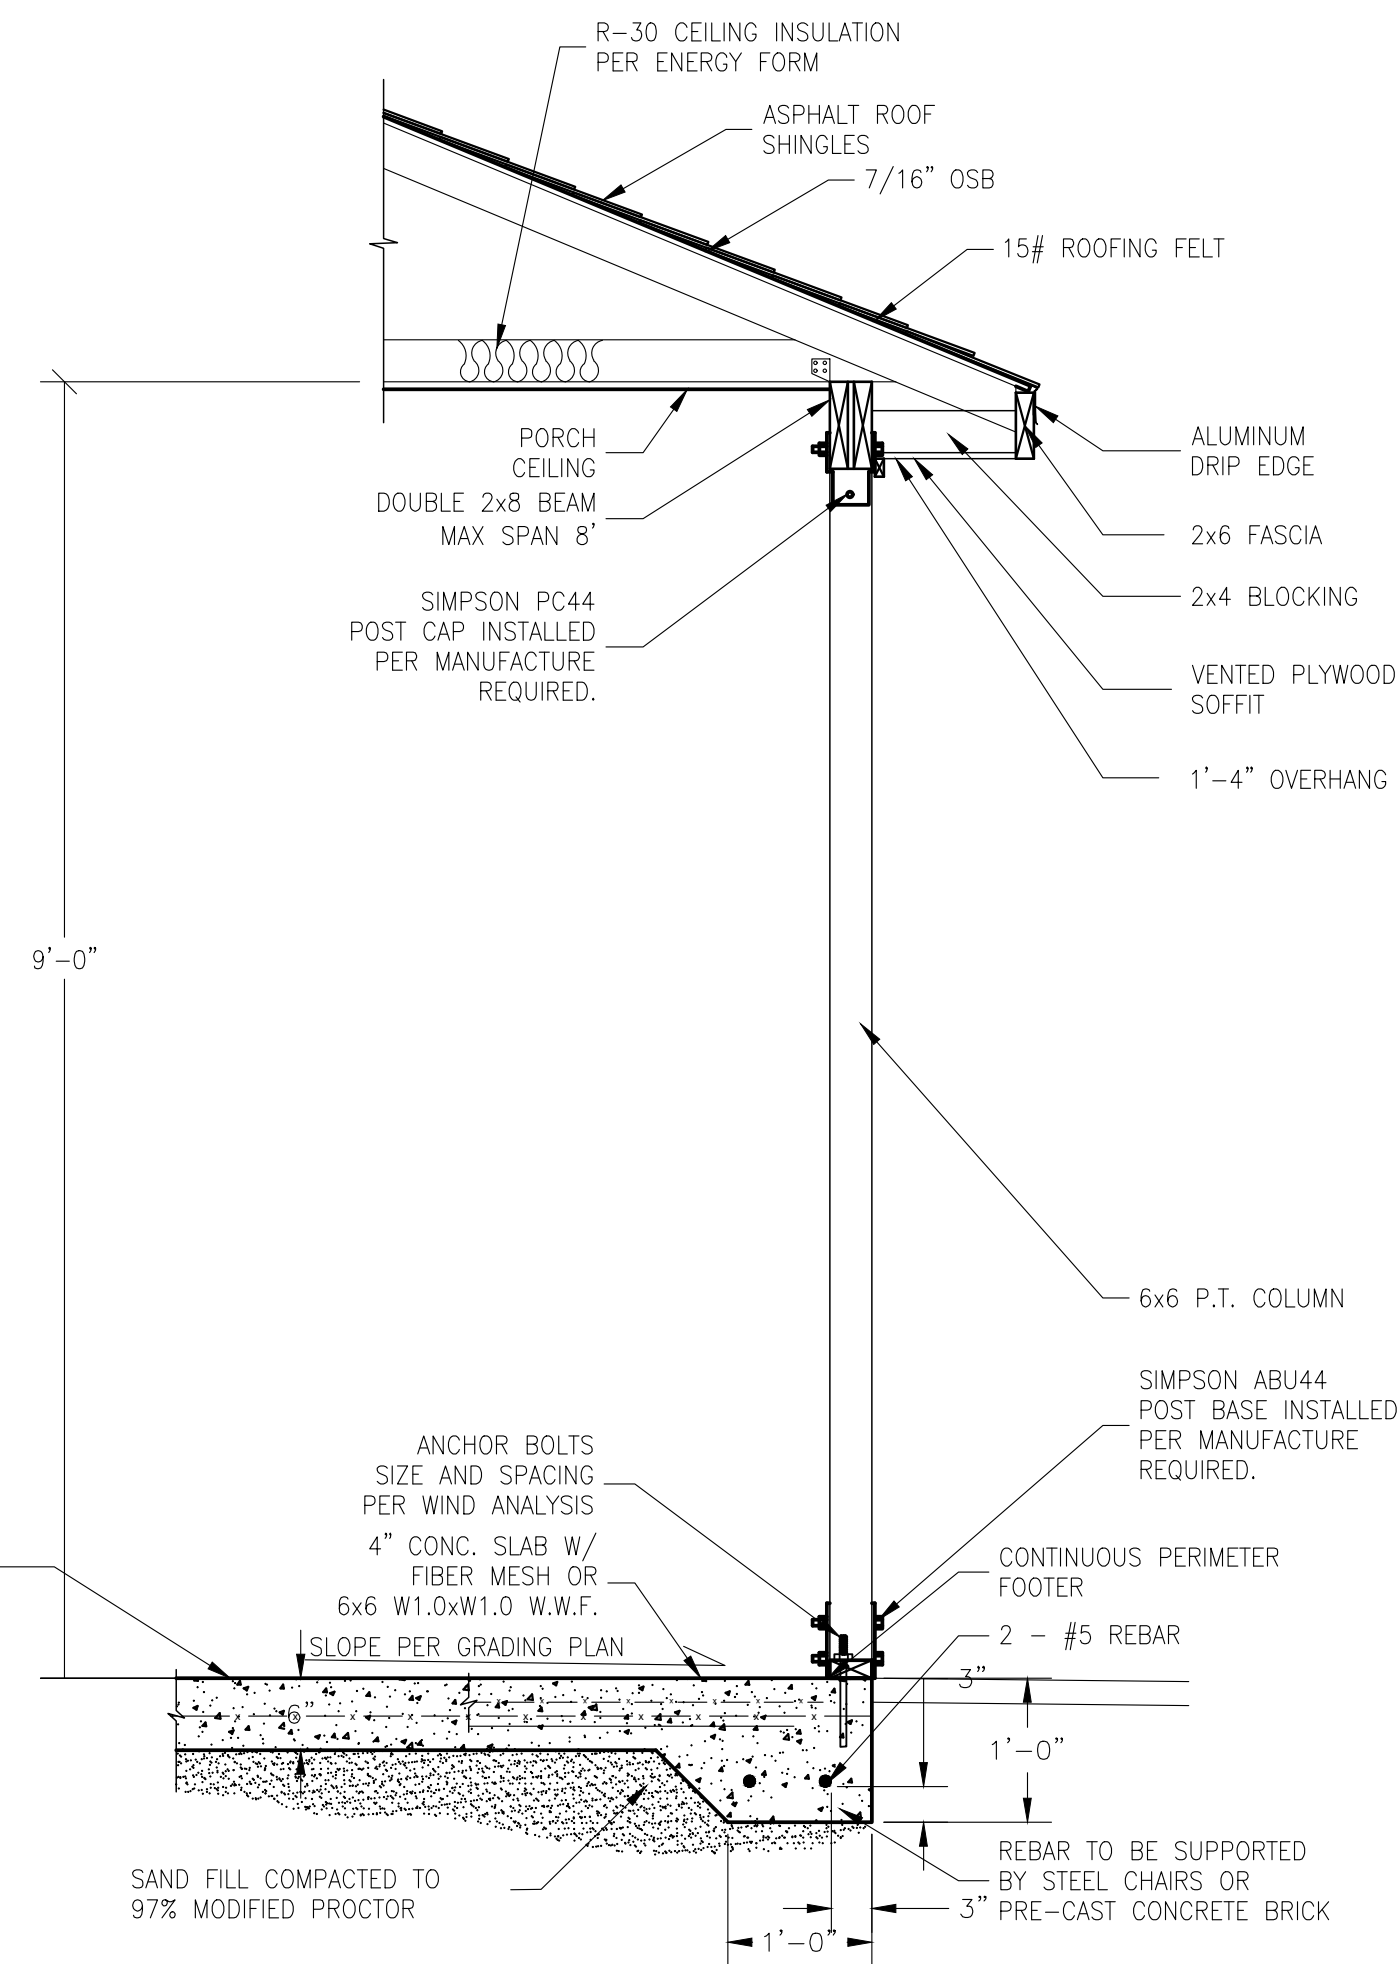

B POST DETAIL
SCALE: 3/4"=1'-0"

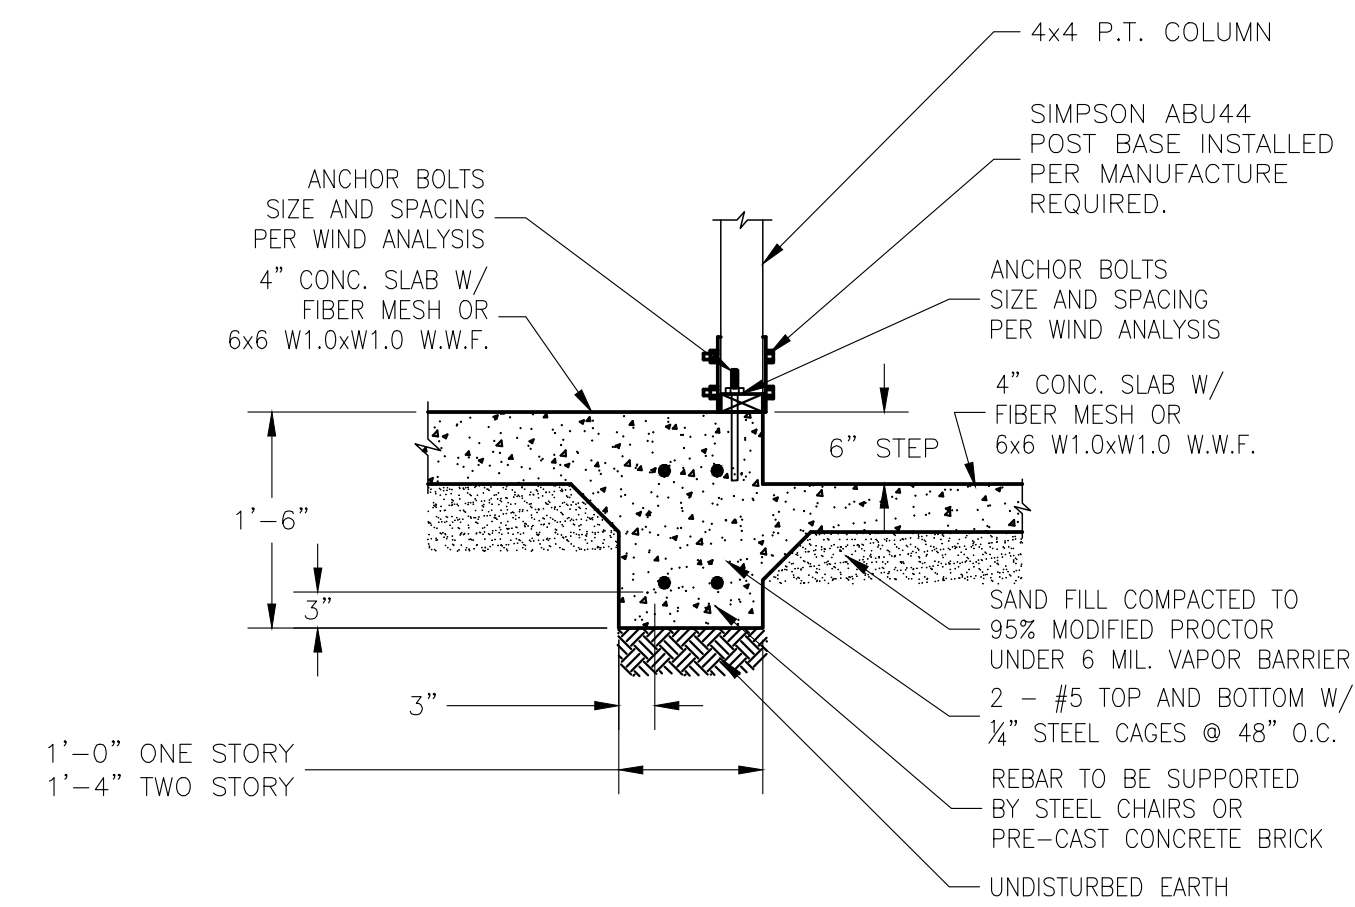

C PORCH STEPDOWN DETAIL
SCALE: 3/4"=1'-0"

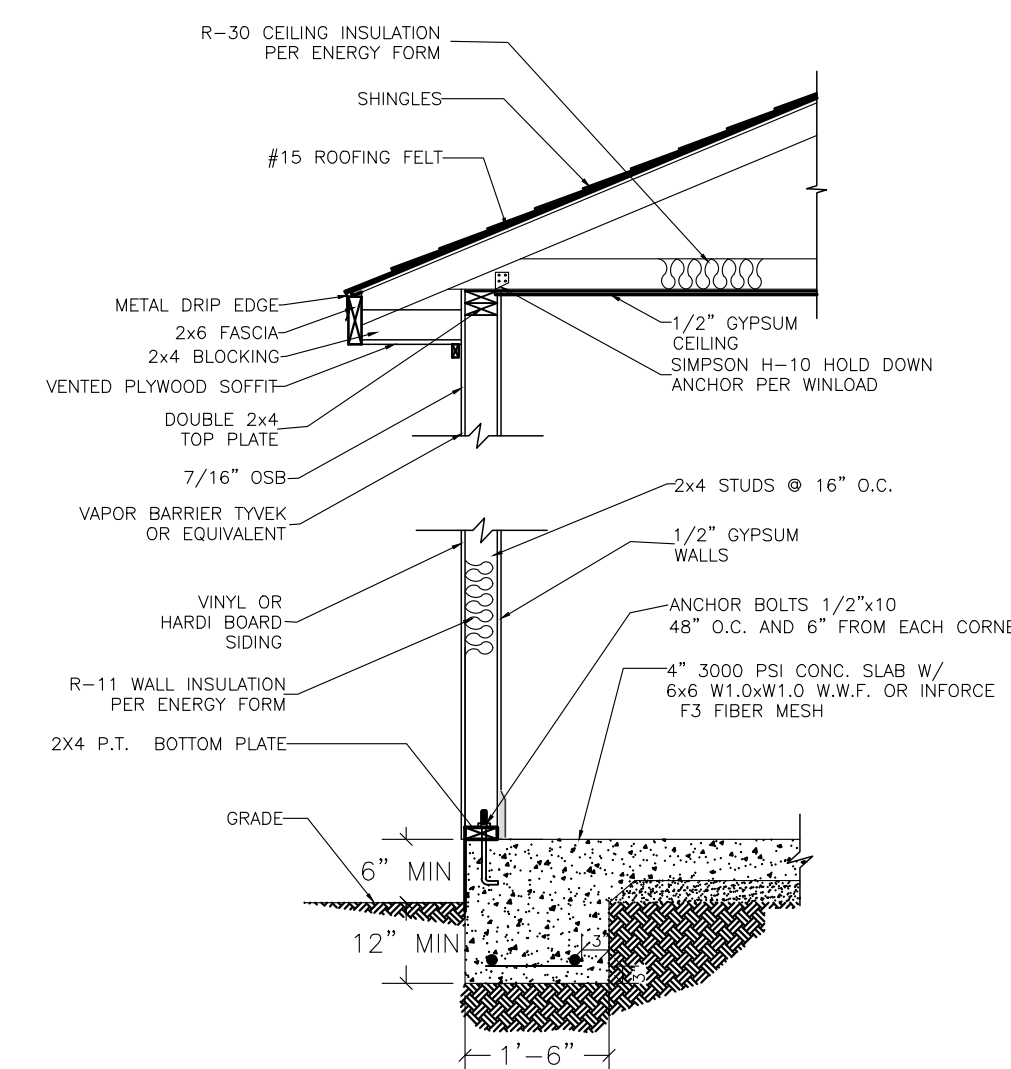

A WALL DETAIL
SCALE: 3/4"=1'-0"

General Notes

CONTRACTOR: TO VERIFY ALL DIMENSION ON SITE OF PROJECT


No.	Revision/Issue	Date

Firm Name and Address
SLOAN'S DRAFTING
96 ALLEN RANCH LANE
HAVANA, FL 32333
(850)-339-1778
sloansdrafting@gmail.com

Project Name and Address
RESTORED GLORY CHRISTIAN CENTER
1346 S JEFFERSON ST.
MONTICELLO, FL 32344

Project CHURCH DESIGN	Sheet
Date 10/31/23	A1.4
Scale 3/4"=1'-0"	

NOT FOR CONSTRUCTION

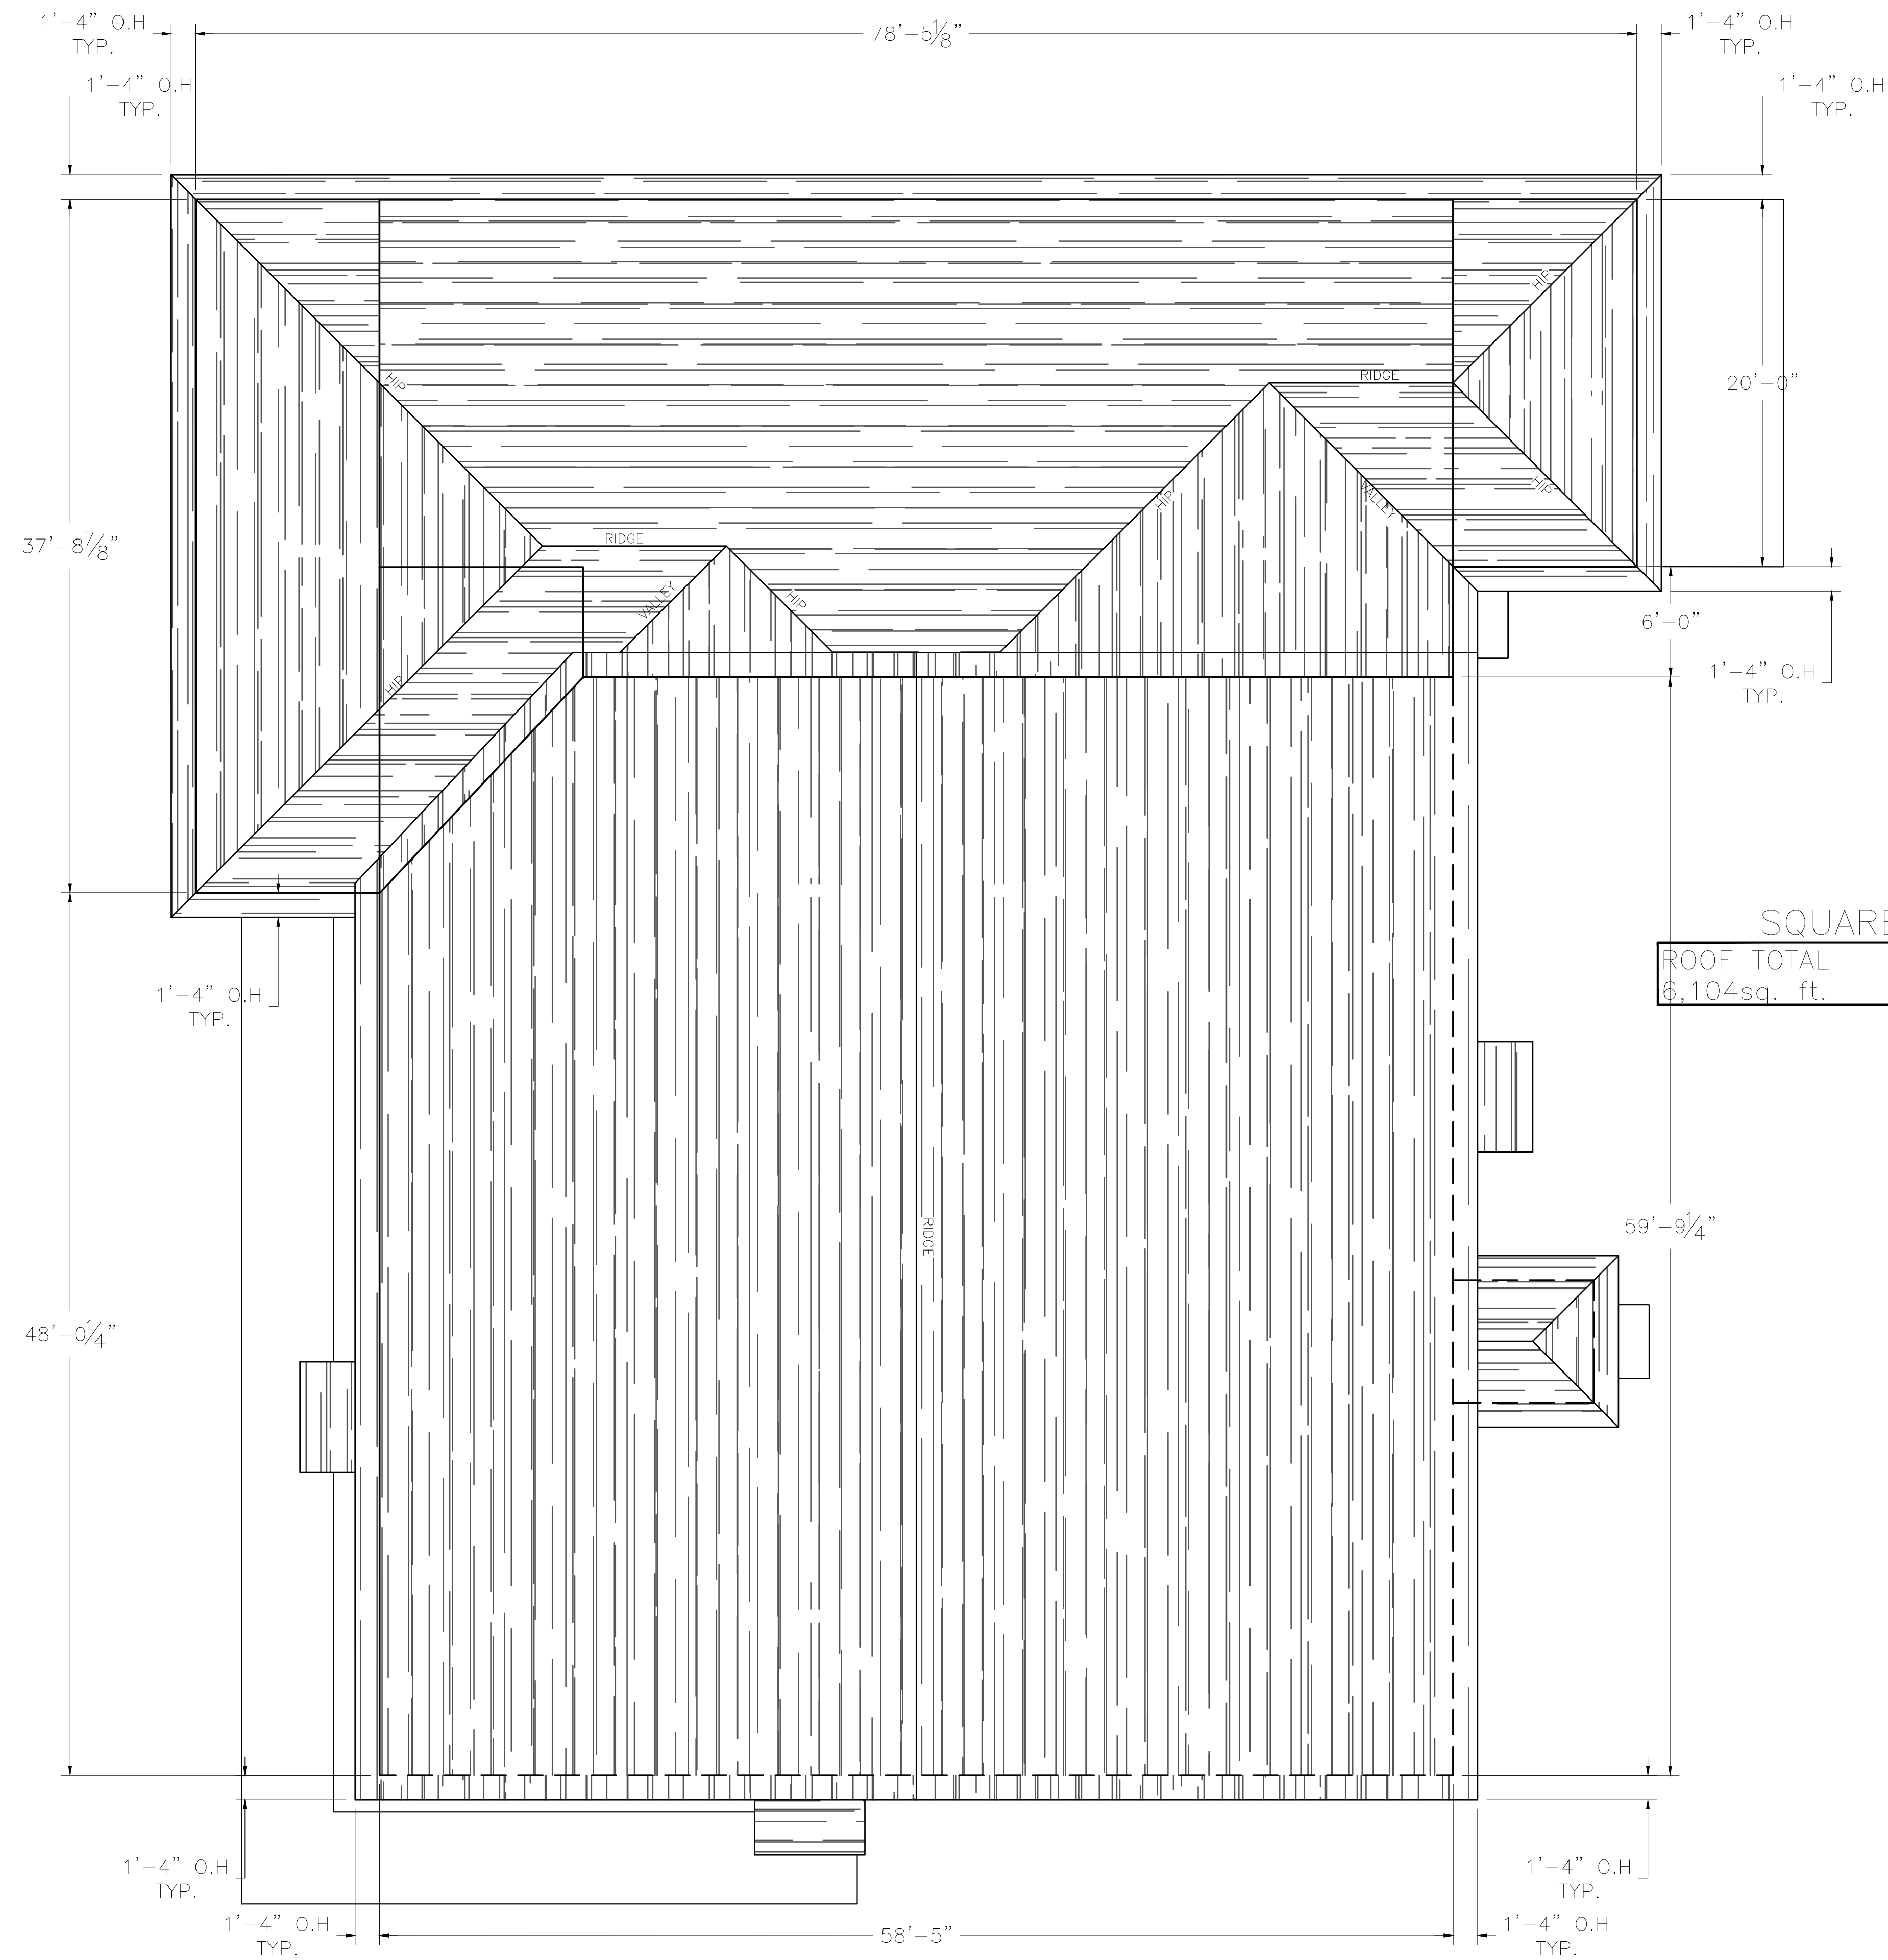

SQUARE FOOTAGE
 ROOF TOTAL
 6,104sq. ft.

ROOFPLAN

SCALE: 3/16"=1'-0"

General Notes

CONTRACTOR: TO VERIFY ALL DIMENSION ON SITE OF PROJECT


No.	Revision/Issue	Date

Firm Name and Address
 SLOAN'S DRAFTING
 96 ALLEN RANCH LANE
 HAVANA, FL 32333
 (850)-339-1778
 sloansdrafting@gmail.com

Project Name and Address
 RESTORED GLORY CHRISTIAN CENTER
 1346 S JEFFERSON ST.
 MONTICELLO, FL 32344


Project CHURCH DESIGN	Sheet
Date 10/31/23	A1.5
Scale 3/16"=1'-0"	

NOT FOR CONSTRUCTION

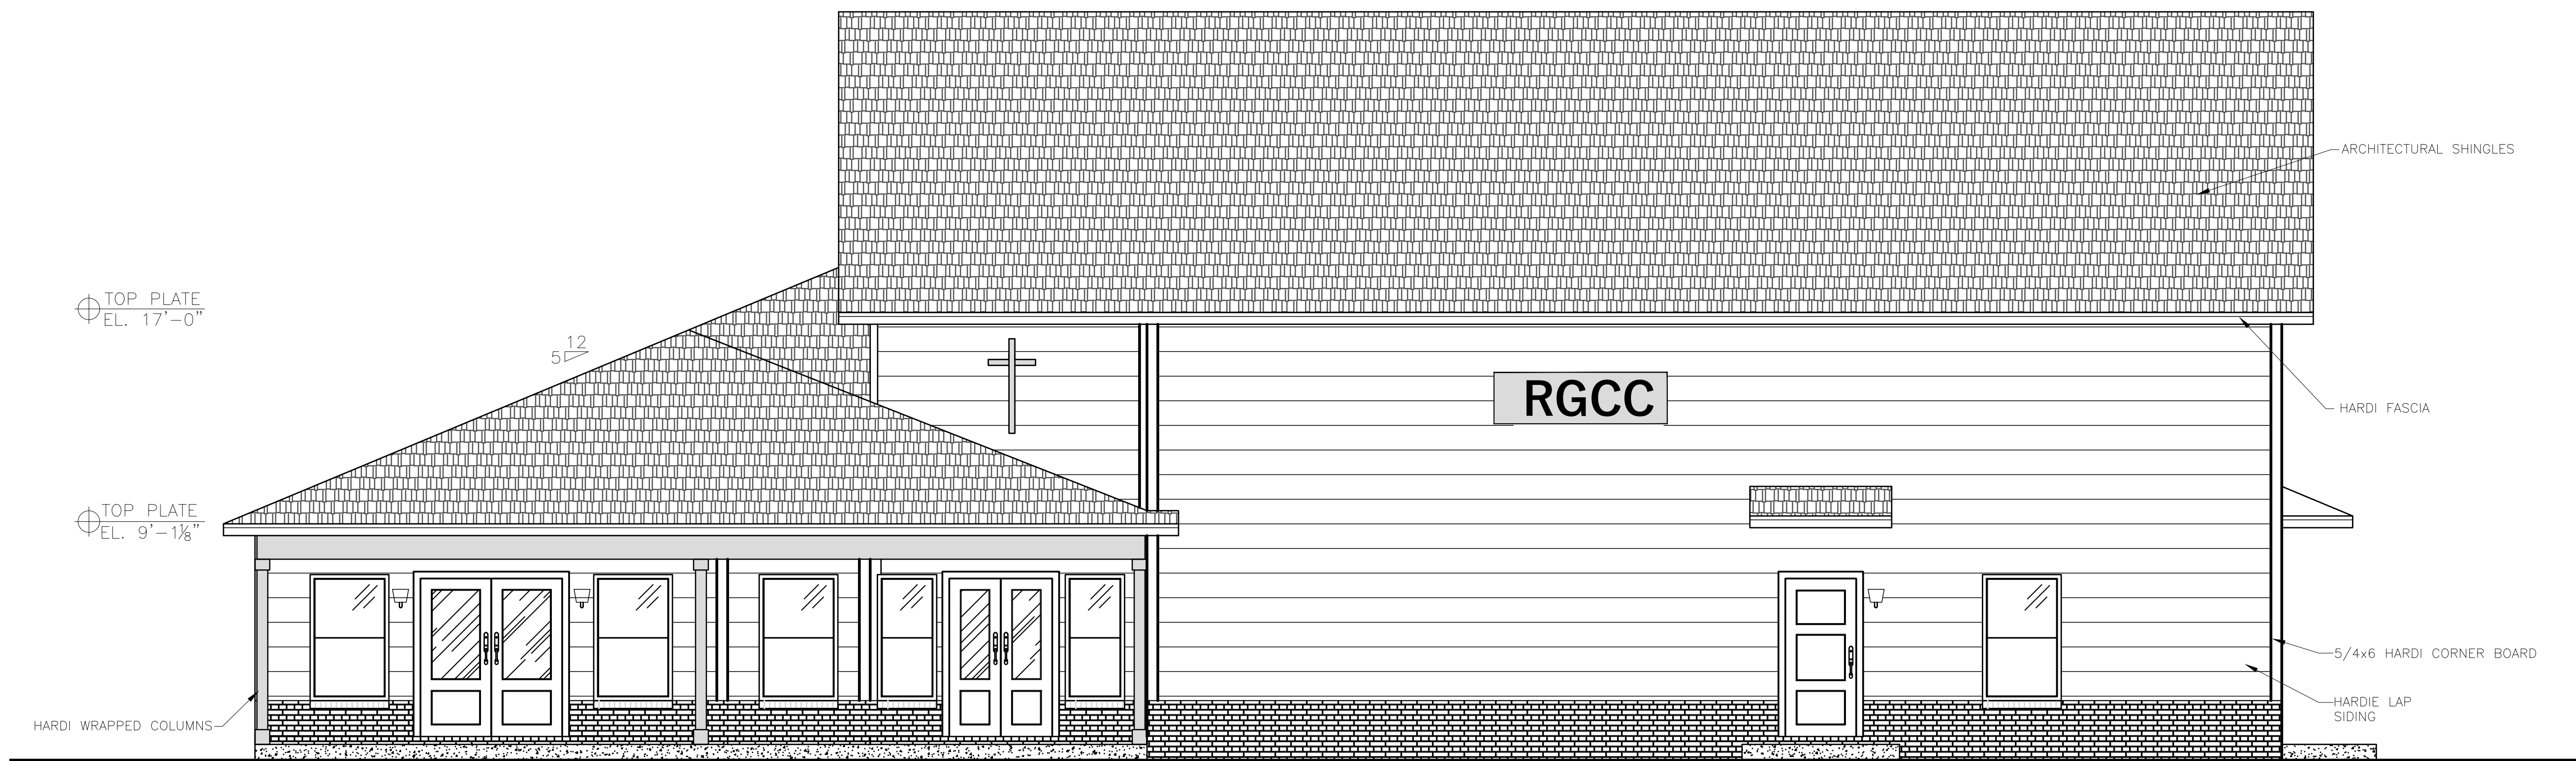

FRONT ELEVATION VIEW

SCALE: 1/4"=1'-0"

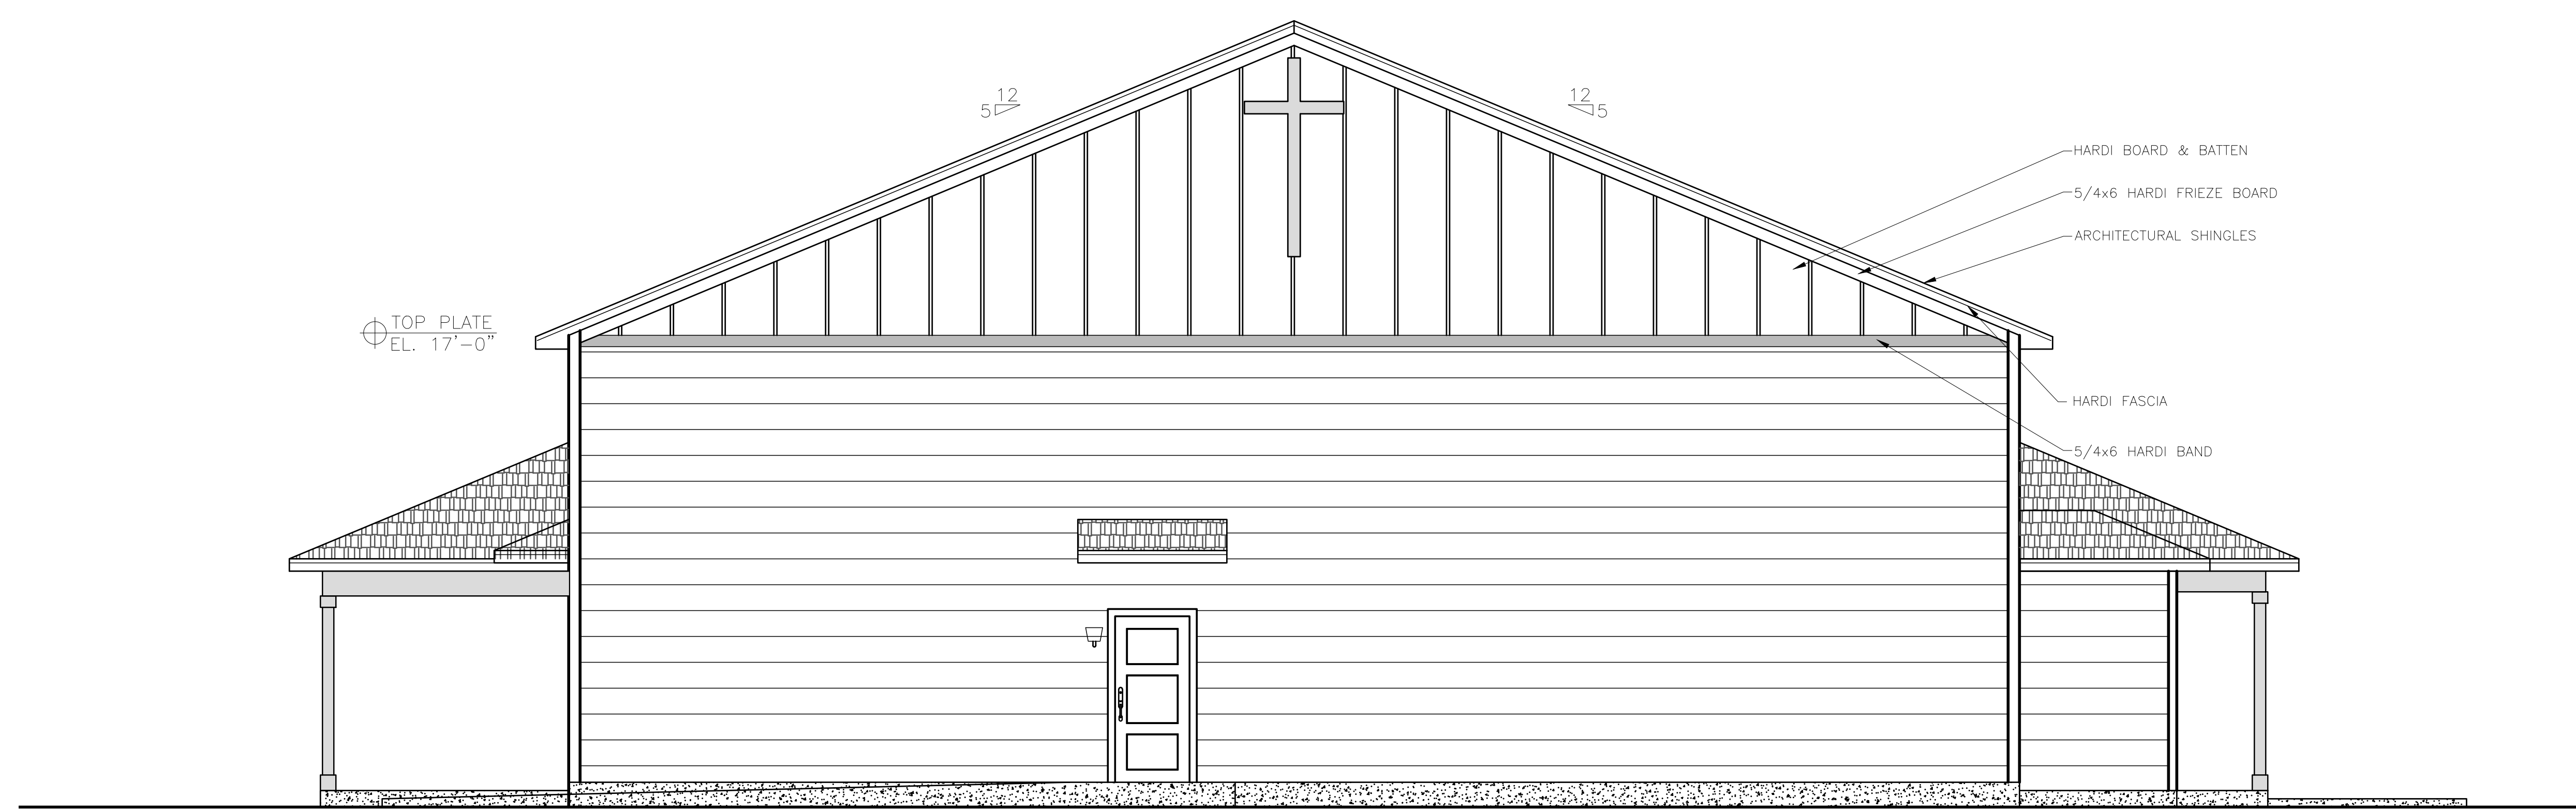

SIDE ELEVATION VIEW

SCALE: 1/4"=1'-0"

General Notes
 CONTRACTOR: TO VERIFY ALL DIMENSION ON SITE OF PROJECT


No.	Revision/Issue	Date

Firm Name and Address
 SLOAN'S DRAFTING
 96 ALLEN RANCH LANE
 HAVANA, FL 32333
 (850)-339-1778
 sloansdrafting@gmail.com

Project Name and Address
 RESTORED GLORY CHRISTIAN CENTER
 1346 S JEFFERSON ST.
 MONTICELLO, FL 32344


Project CHURCH DESIGN	Sheet
Date 10/31/23	A1.6
Scale 1/4"=1'-0"	

NOT FOR CONSTRUCTION

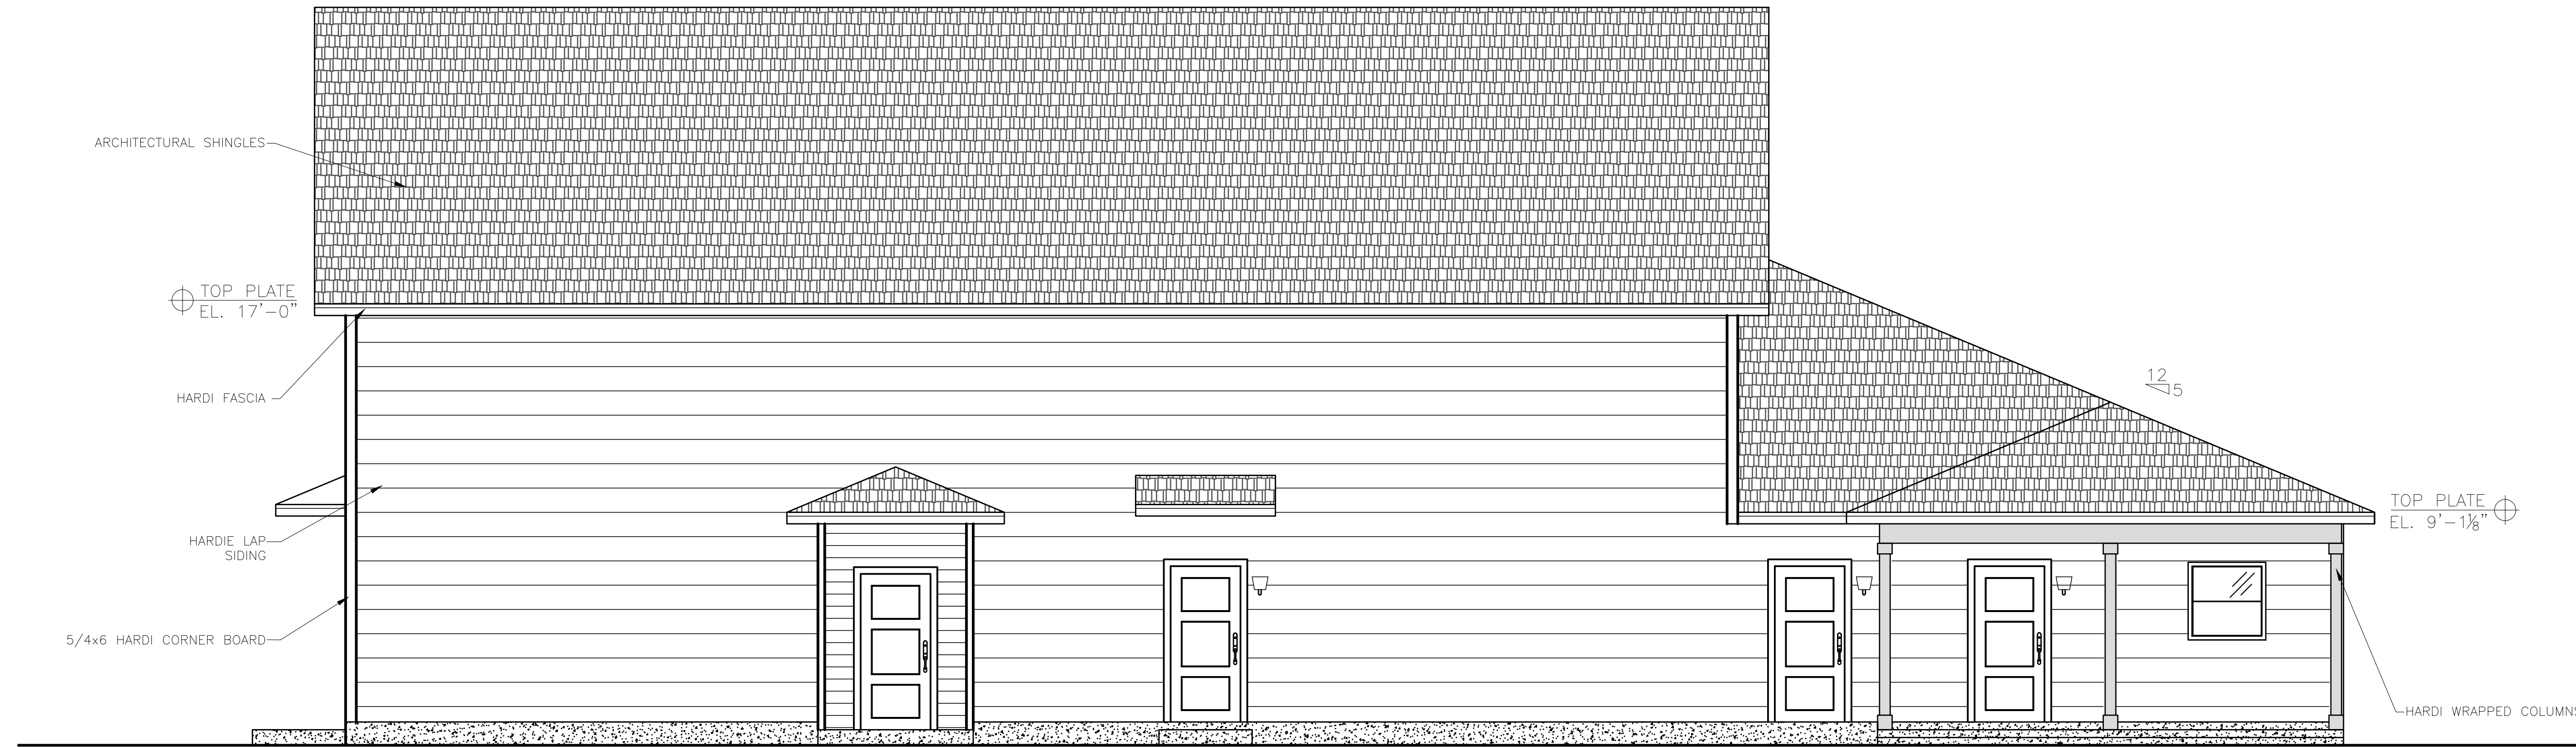

BACK ELEVATION VIEW

SCALE: 1/4"=1'-0"

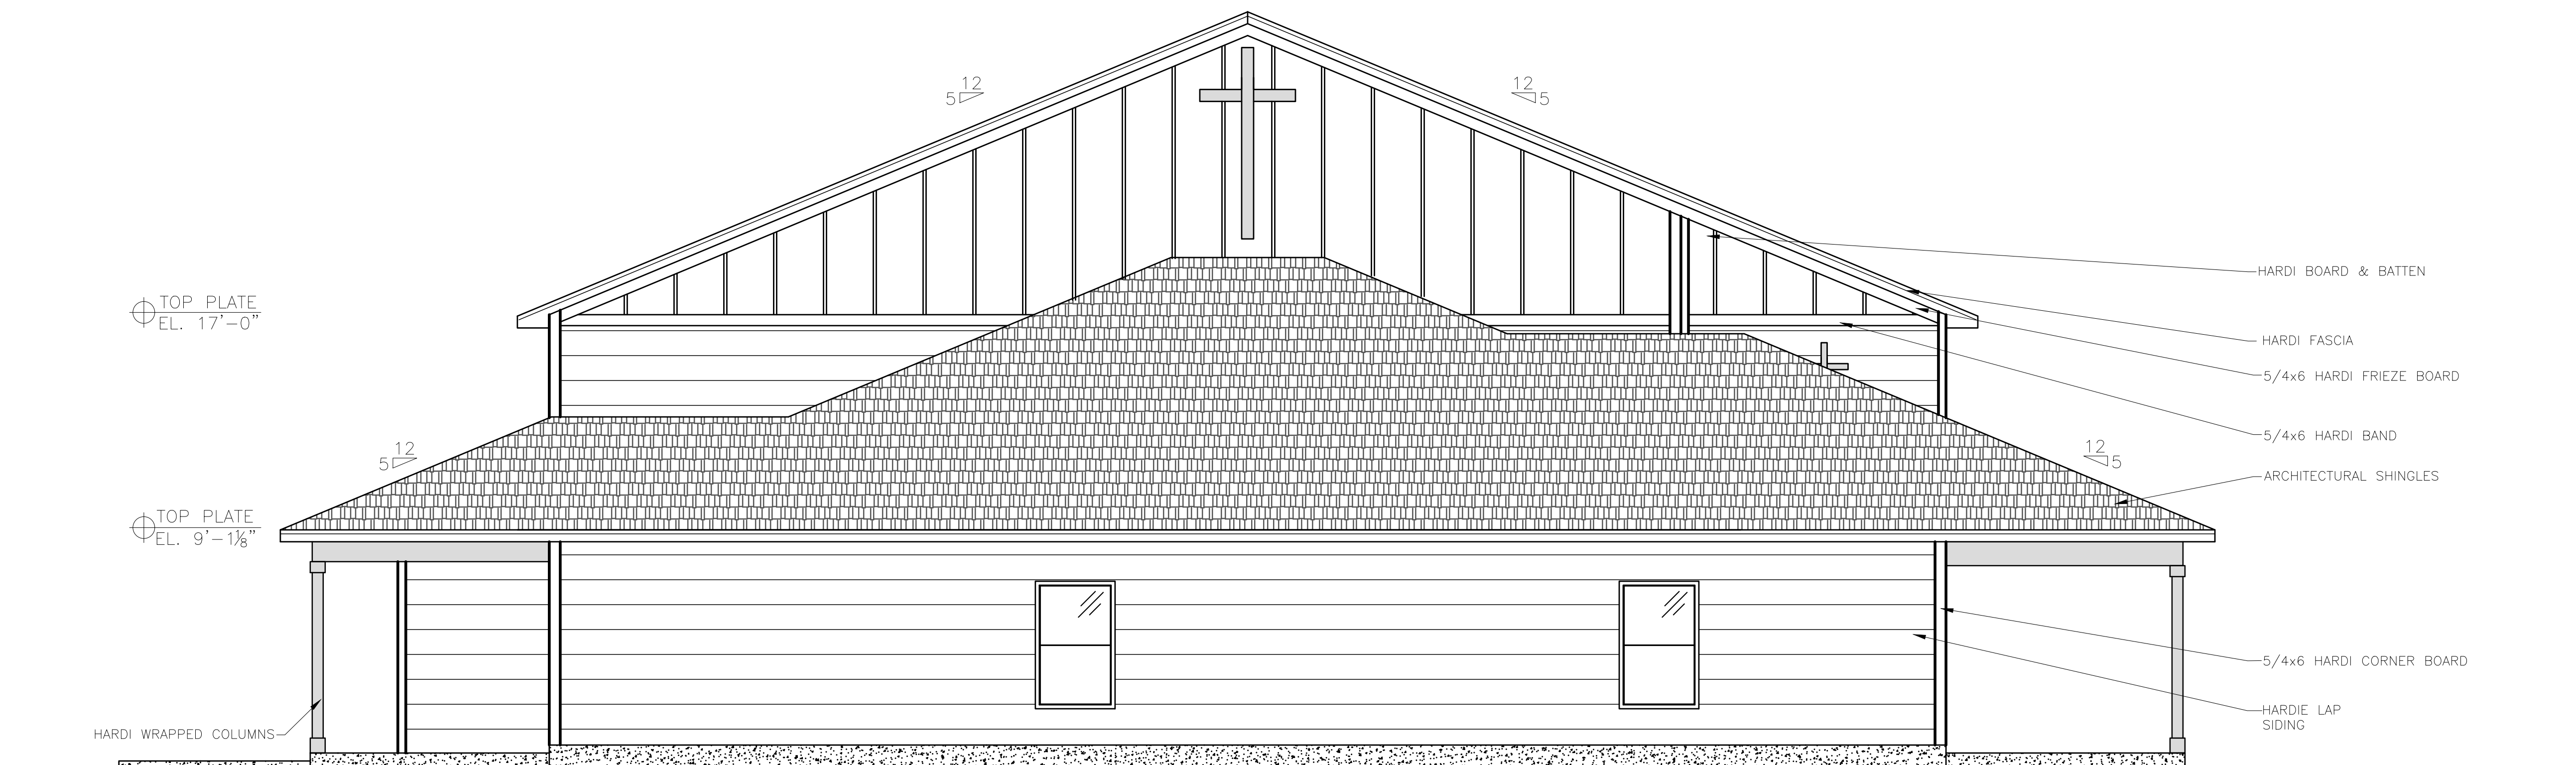

SIDE ELEVATION VIEW

SCALE: 1/4"=1'-0"

General Notes

CONTRACTOR: TO VERIFY ALL DIMENSION ON SITE OF PROJECT

No.	Revision/Issue	Date

Firm Name and Address
 SLOAN'S DRAFTING
 96 ALLEN RANCH LANE
 HAVANA, FL 32333
 (850)-339-1778
 sloansdrafting@gmail.com

Project Name and Address
 RESTORED GLORY CHRISTIAN CENTER
 1346 S JEFFERSON ST.
 MONTICELLO, FL 32344

Project CHURCH DESIGN	Sheet
Date 10/31/23	A1.7
Scale 1/4"=1'-0"	